


WASHINGTON METROPOLITAN AREA TRANSIT AUTHORITY



**MTPD DISTRICT II POLICE STATION
POLICE TRAINING FACILITY
FAIRFAX COUNTY, VIRGINIA**

GENERAL PLANS

JUNE 16, 2011

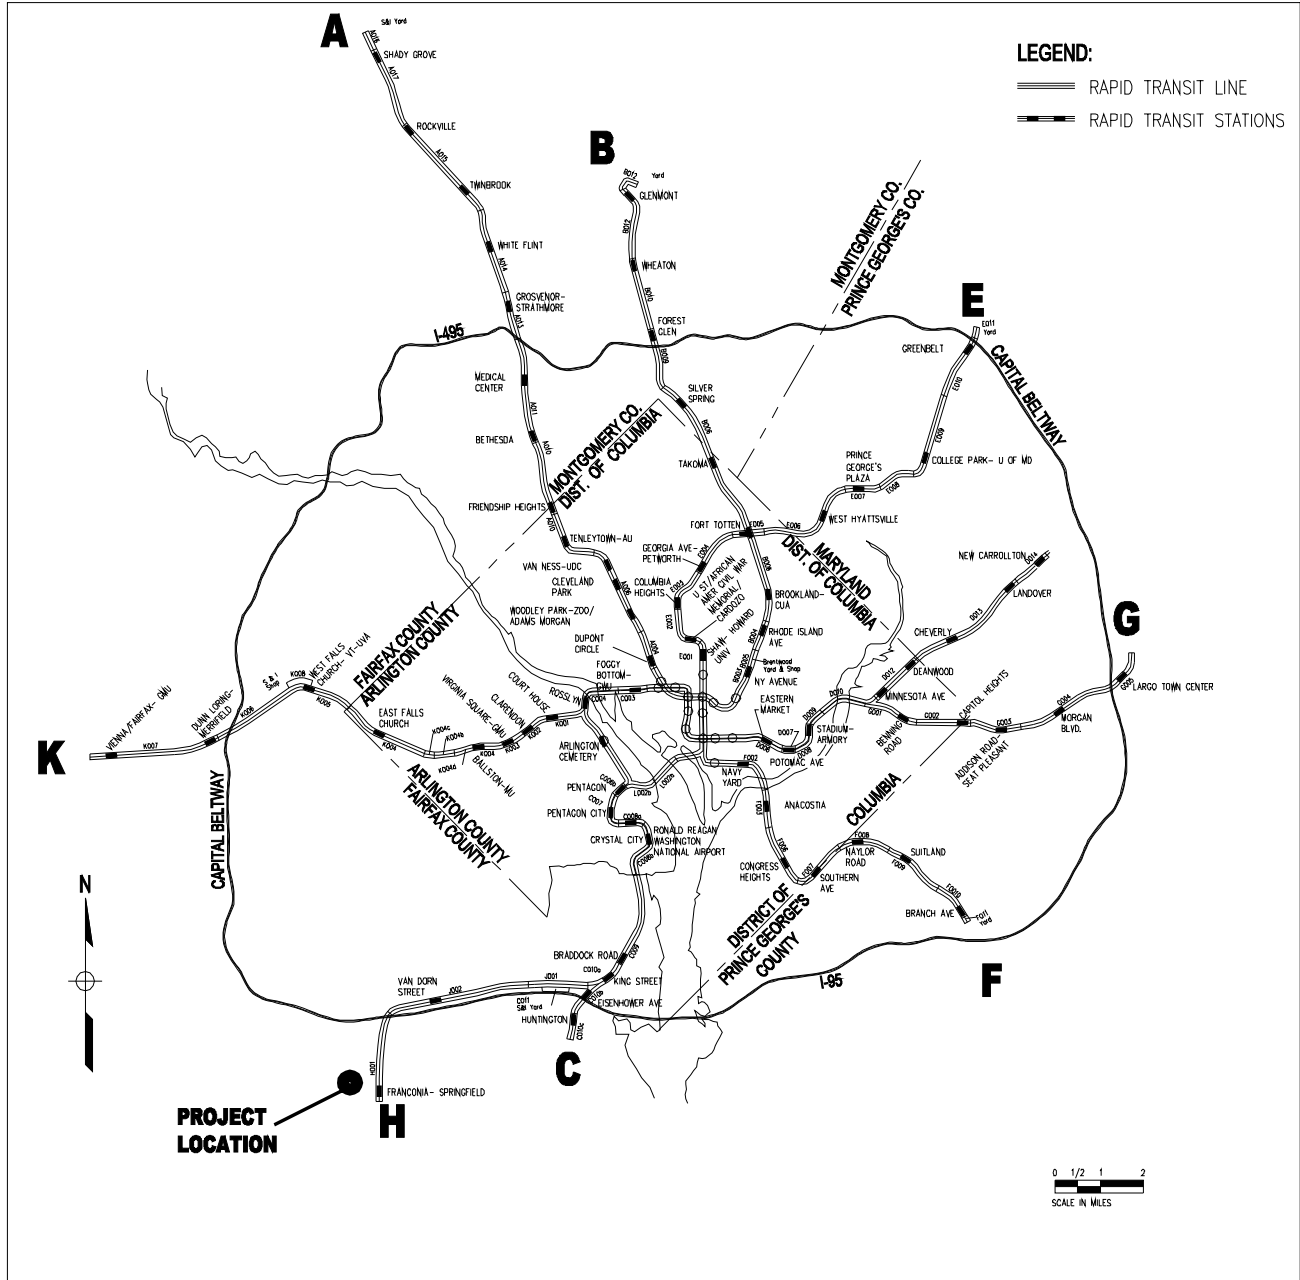

SYSTEM MAP



LOCATION MAP
NOT TO SCALE


DESIGNED	M. REDDY	06/11
		DATE
DRAWN	M. REDDY	06/11
		DATE
CHECKED	R. AMIN	06/11
		DATE
APPROVED	M. POWERS	06/11
		DATE

REFERENCE DRAWINGS	
NUMBER	DESCRIPTION

REVISIONS		
DATE	BY	DESCRIPTION

WASHINGTON METROPOLITAN AREA TRANSIT AUTHORITY

AECOM



HALF SIZE PRINT	CONTRACT NO.
MTPD DISTRICT II POLICE STATION POLICE TRAINING FACILITY SYSTEM MAP AND LOCATION PLAN	
SCALE: NOT TO SCALE	DRAWING NO. G-02

INDEX OF DRAWINGS

MTPD DISTRICT II POLICE STATION


POLICE TRAINING FACILITY

FAIRFAX COUNTY, VIRGINIA

GENERAL PLANS

DRAWING NO.	DRAWING DESCRIPTION
G-01	COVER SHEET
G-02	SYSTEM MAP AND LOCATION PLAN
G-03	INDEX OF DRAWINGS
G-04	SITE PLAN
G-05	POLICE STATION EXTERIOR ELEVATIONS
G-06	POLICE TRAINING FACILITY EXTERIOR ELEVATIONS
G-07	POLICE STATION & TRAINING FACILITY PERSPECTIVE VIEWS
G-08	POLICE STATION & TRAINING FACILITY PERSPECTIVE VIEWS

										HALF SIZE PRINT		CONTRACT NO.
DESIGNED	M. REDDY	06/11	REFERENCE DRAWINGS		REVISIONS			WASHINGTON METROPOLITAN AREA TRANSIT AUTHORITY			MTPD DISTRICT II POLICE STATION POLICE TRAINING FACILITY INDEX OF DRAWINGS	
		DATE	NUMBER	DESCRIPTION	DATE	BY	DESCRIPTION					
DRAWN	M. REDDY	06/11						<div><div>AECOM</div><div><div>M</div><div>metro</div></div></div>				
		DATE										
CHECKED	R. AMIN	06/11										
		DATE										
APPROVED	M. POWERS	06/11										
		DATE									SCALE:	DRAWING NO.
										NOT TO SCALE	G-03	

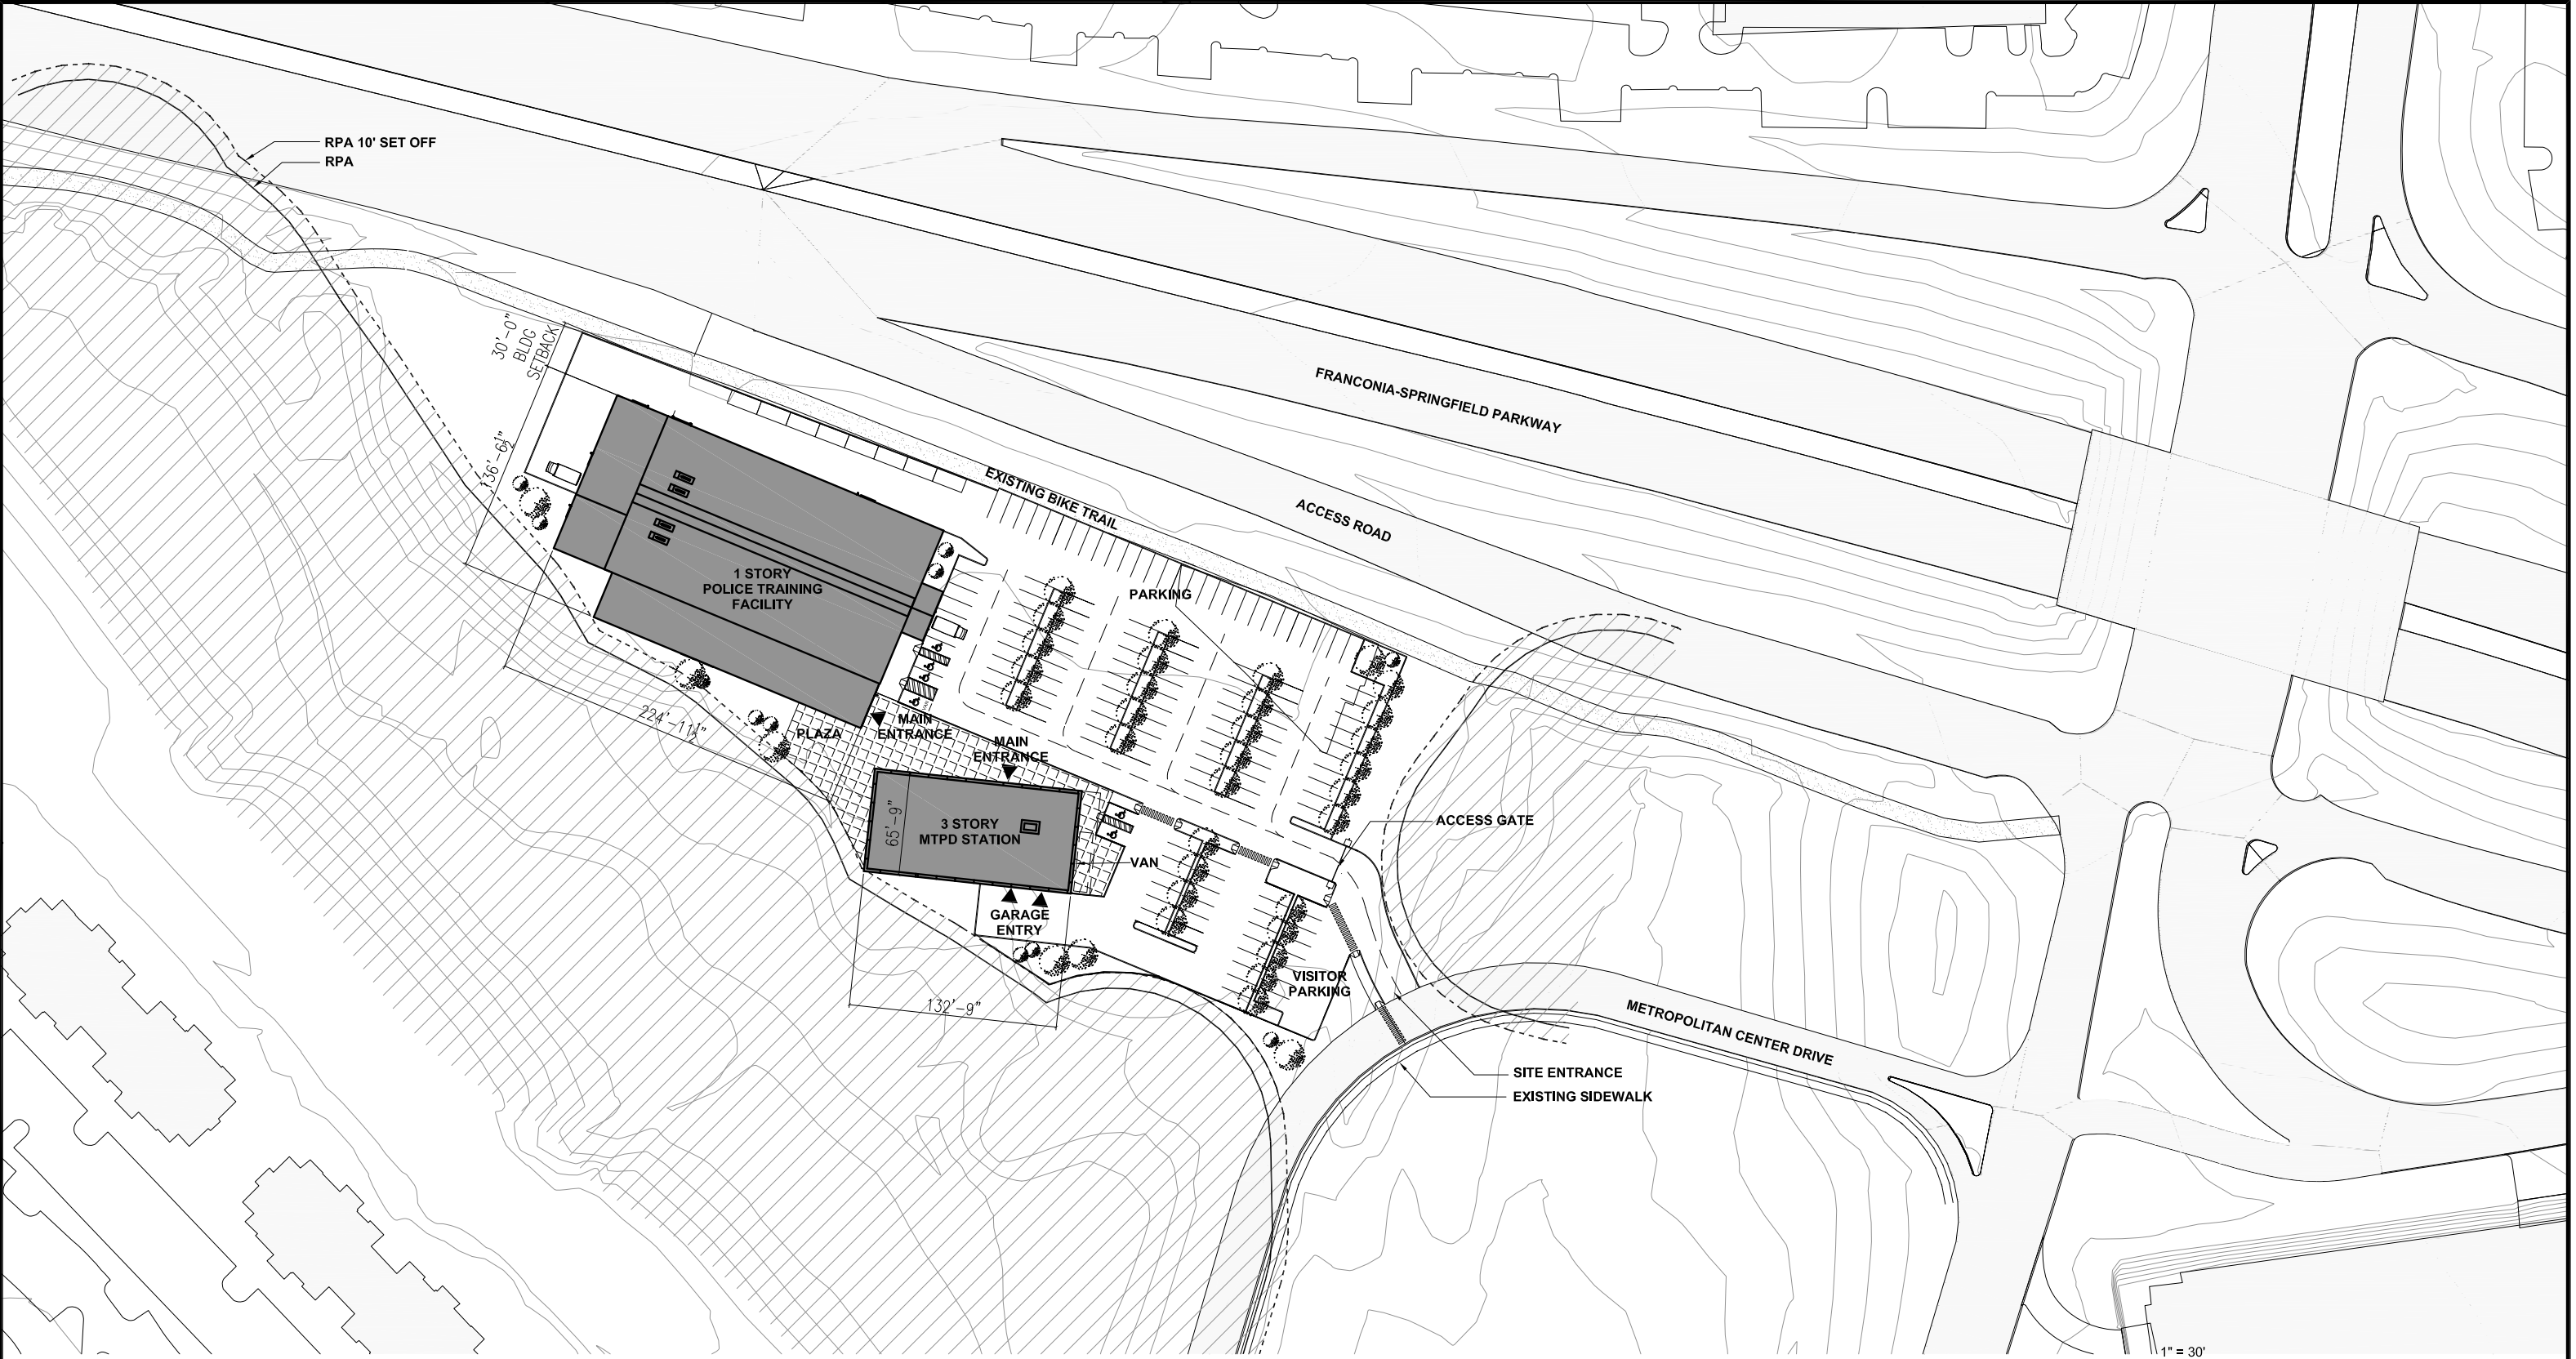


1 SITE PLAN
PARKING SPACES = 142 (8 SPACES PARALLEL)

DESIGNED	D. PAINE	06/16/11
	DATE	
DRAWN	B. BLOUNT	06/16/11
	DATE	
CHECKED	D. PAINE	06/16/11
	DATE	
APPROVED	D. PAINE	06/16/11
	DATE	


REFERENCE DRAWINGS	
NUMBER	DESCRIPTION

REVISIONS		
DATE	BY	DESCRIPTION


WASHINGTON METROPOLITAN AREA TRANSIT AUTHORITY




HALF SIZE PRINT	CONTRACT NO.
MTPD DISTRICT II POLICE STATION POLICE TRAINING FACILITY SITE PLAN	
SCALE:	DRAWING NO. G-04

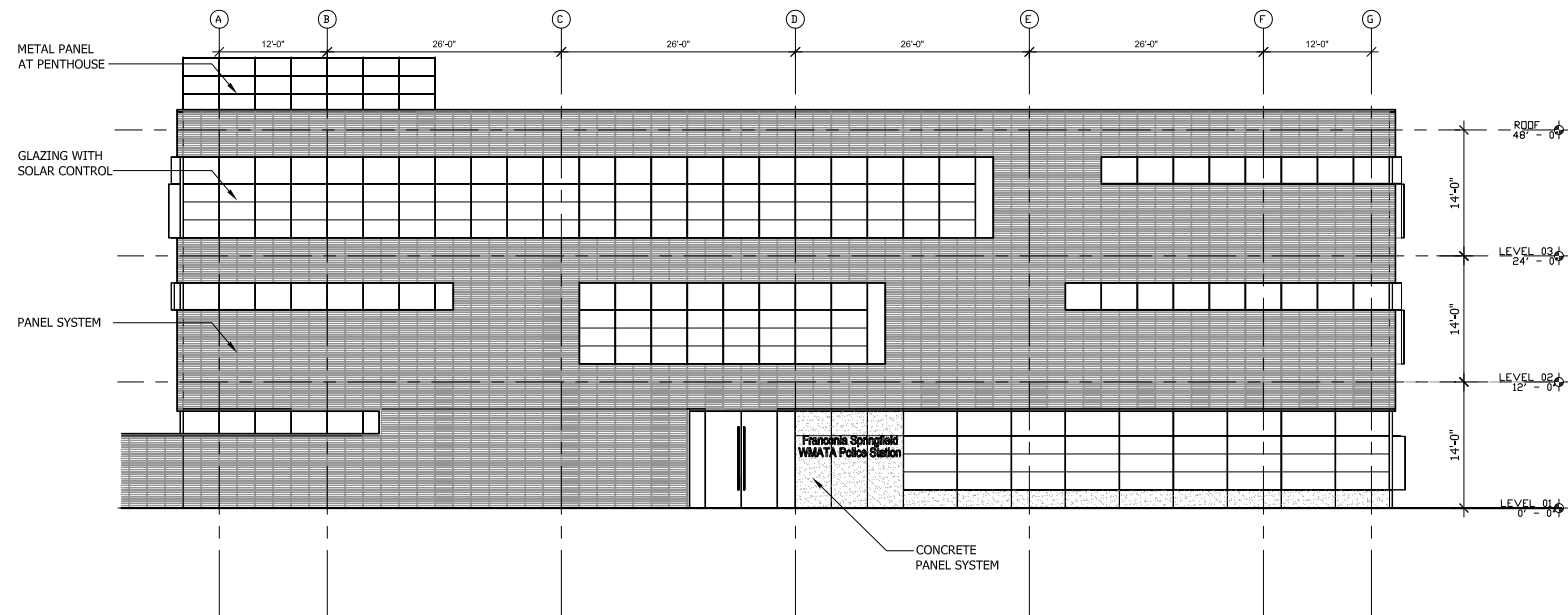


3 SOUTH ELEVATION

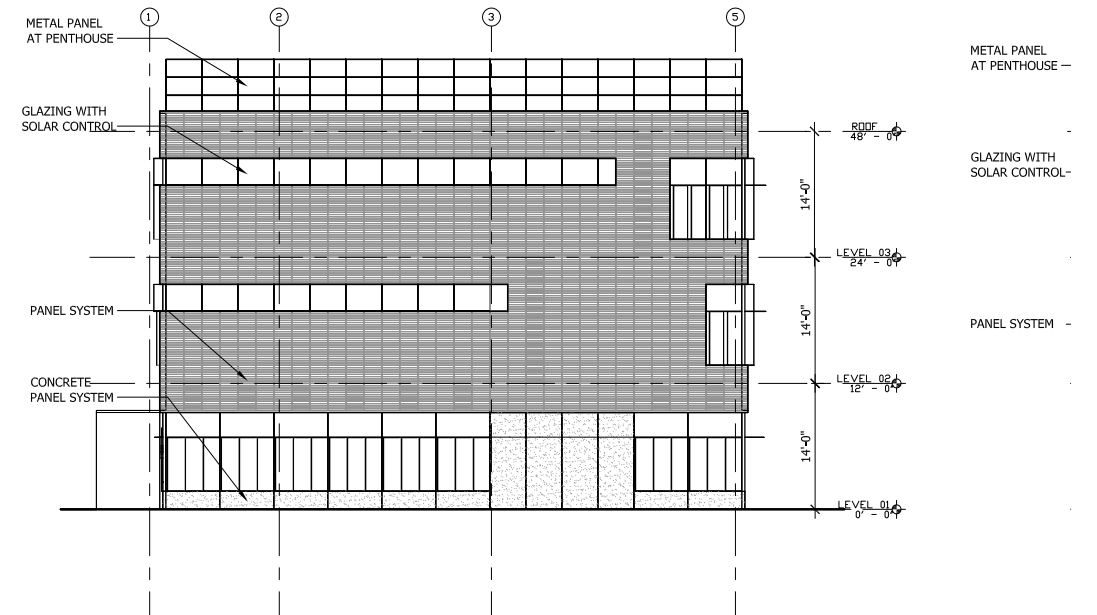


2 EAST ELEVATION

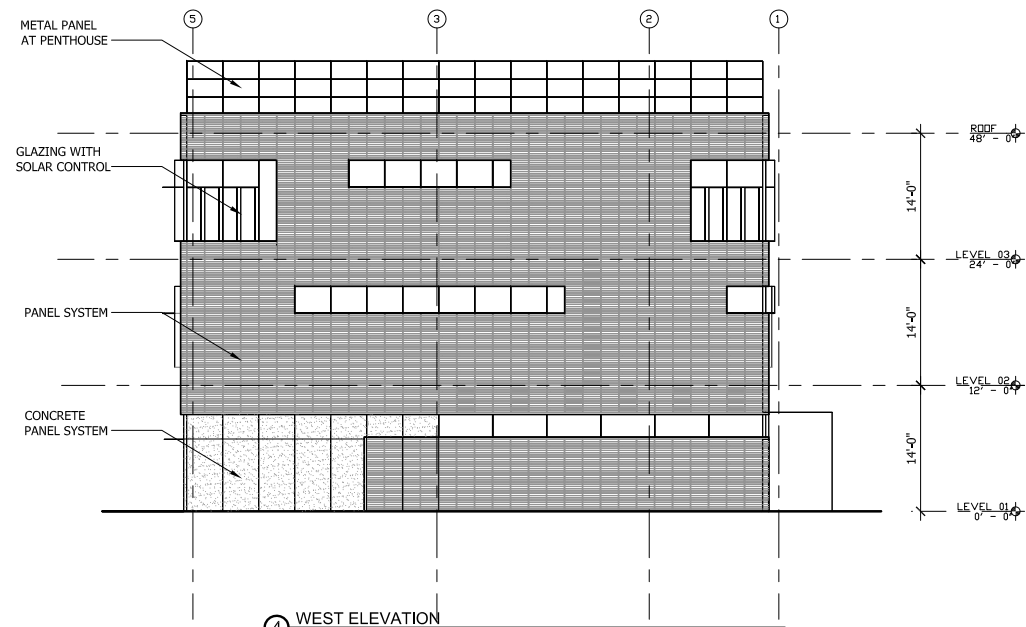

4 WEST ELEVATION

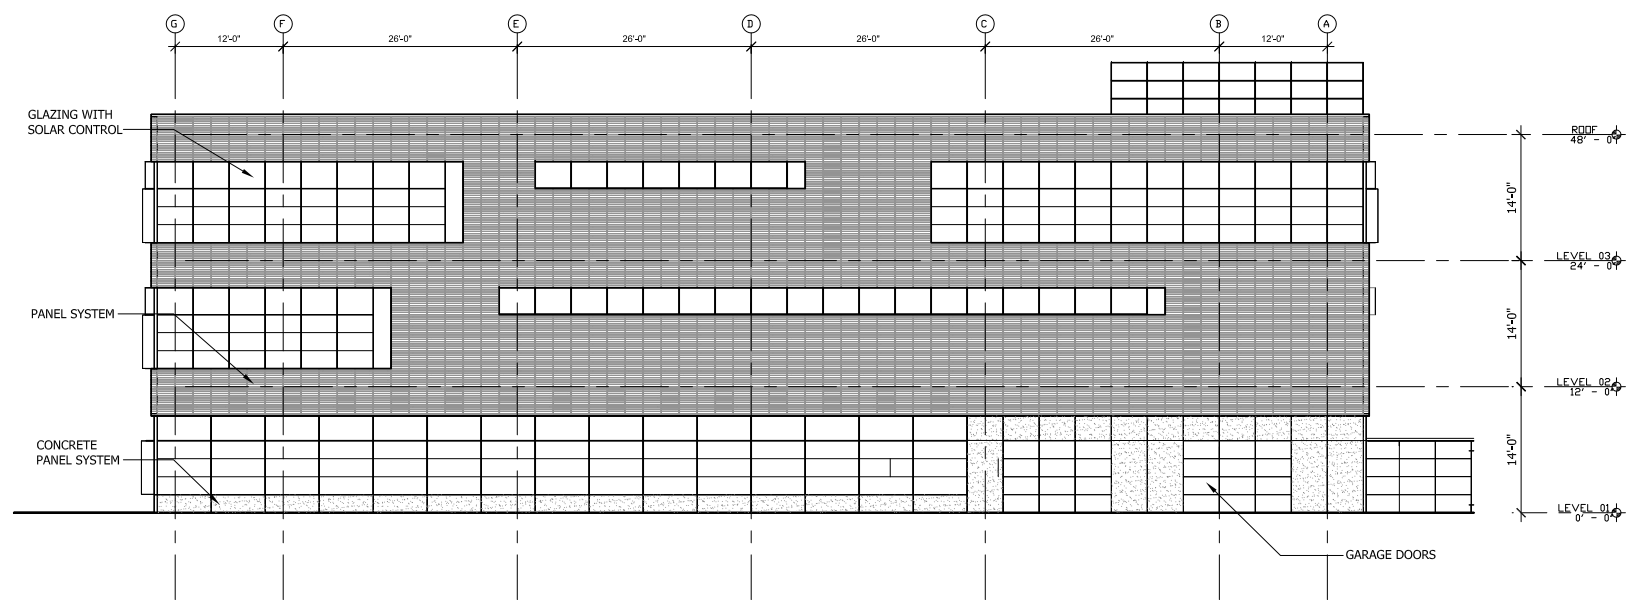

1 NORTH ELEVATION

 

REFERENCE DRAWINGS				REVISIONS		
DESIGNED	DATE	NUMBER	DESCRIPTION	DATE	BY	DESCRIPTION
D. PAINE	06/16/11					
	DATE					
DRAWN	06/16/11					
B. BLOUNT	DATE					
CHECKED	06/16/11					
D. PAINE	DATE					
APPROVED	06/16/11					
D. PAINE	DATE					

WASHINGTON METROPOLITAN AREA TRANSIT AUTHORITY



HALF SIZE PRINT


CONTRACT NO.

MTPD DISTRICT II POLICE STATION
POLICE STATION
EXTERIOR ELEVATIONS


SCALE:

DRAWING NO.


G-05

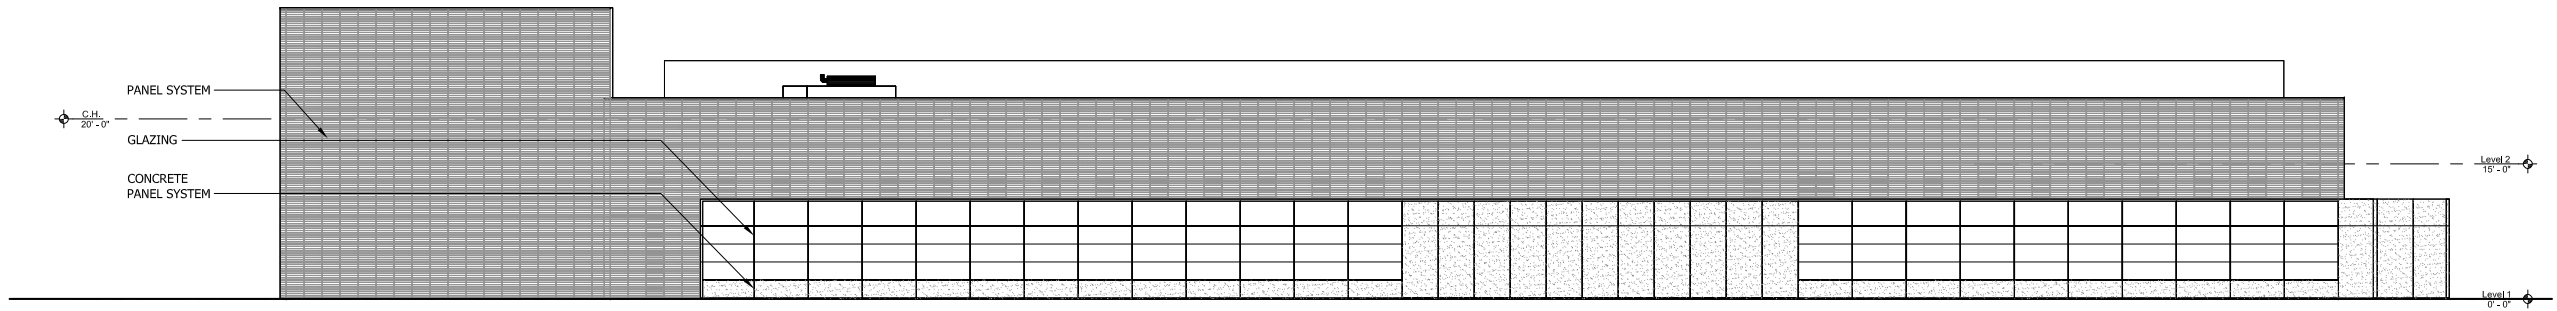


④ SOUTH ELEVATION

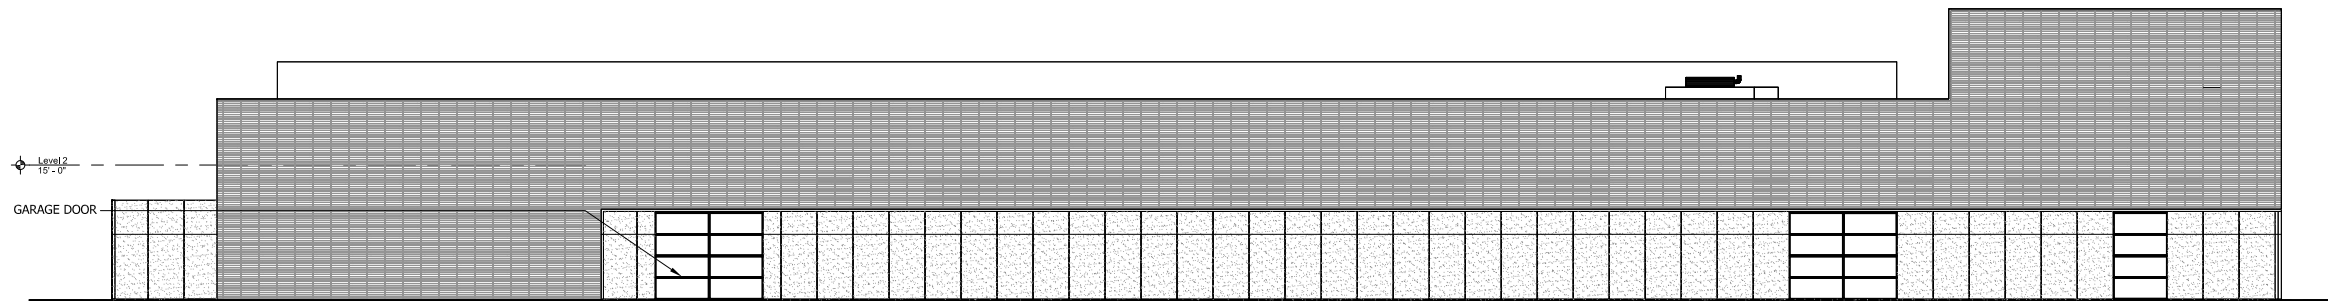


③ NORTH ELEVATION

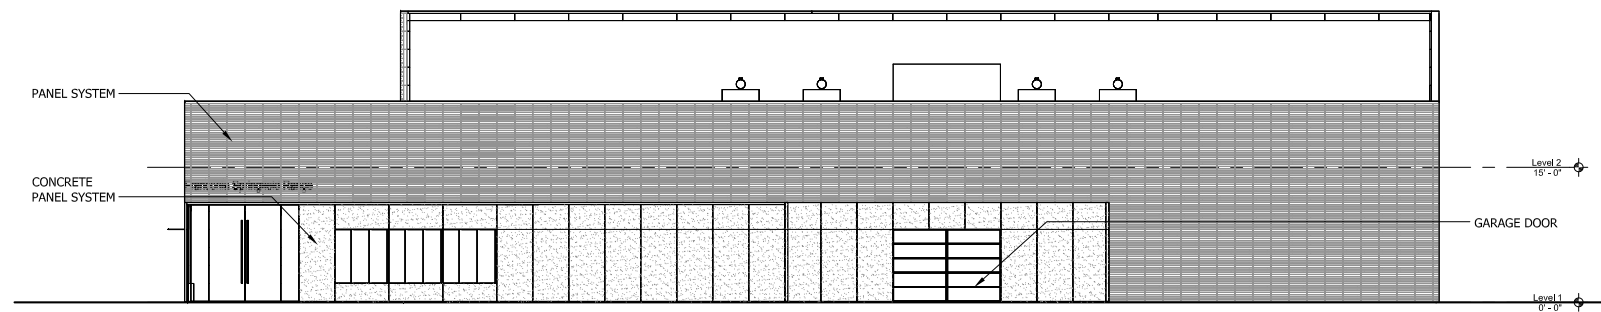

② EAST ELEVATION

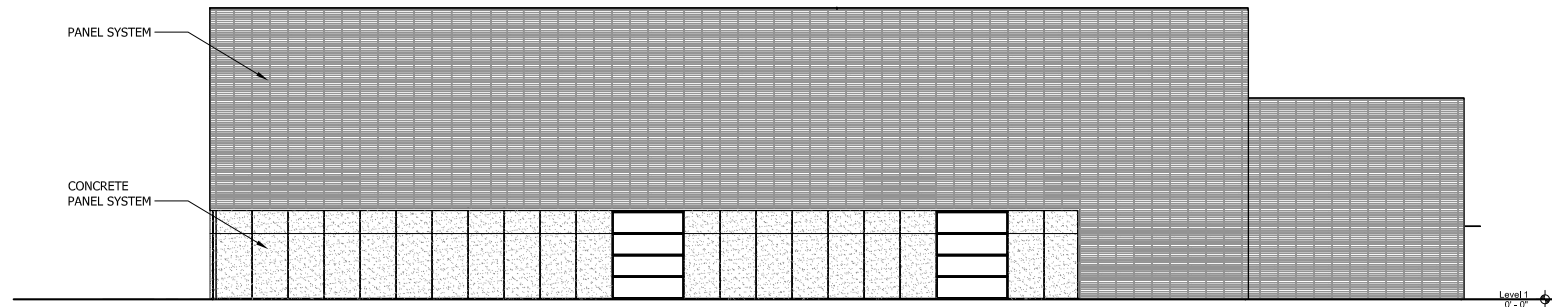

① WEST ELEVATION

 

DESIGNED <u>D. PAINE</u> 06/16/11 DATE		REFERENCE DRAWINGS		REVISIONS		WASHINGTON METROPOLITAN AREA TRANSIT AUTHORITY		MTPD DISTRICT II POLICE STATION POLICE TRAINING FACILITY EXTERIOR ELEVATIONS		CONTRACT NO.	
DRAWN <u>B. BLOUNT</u> 06/16/11 DATE		NUMBER	DESCRIPTION	DATE	BY	DESCRIPTION			SCALE:	DRAWING NO.	
CHECKED <u>D. PAINE</u> 06/16/11 DATE										G-06	
APPROVED <u>D. PAINE</u> 06/16/11 DATE											



② PERSPECTIVE VIEW FROM METROPOLITAN CENTER DRIVE




① PERSPECTIVE VIEW FROM FRANCONIA SPRINGFIELD PARKWAY

DESIGNED	D. PAINE	06/16/11
		DATE
DRAWN	B. BLOUNT	06/16/11
		DATE
CHECKED	D. PAINE	06/16/11
		DATE
APPROVED	D. PAINE	06/16/11
		DATE

REFERENCE DRAWINGS	
NUMBER	DESCRIPTION

REVISIONS		
DATE	BY	DESCRIPTION

WASHINGTON METROPOLITAN AREA TRANSIT AUTHORITY



HALF SIZE PRINT		CONTRACT NO.
MTPD DISTRICT II POLICE STATION POLICE TRAINING FACILITY PERSPECTIVE VIEWS		
SCALE:	DRAWING NO. G-07	




② PERSPECTIVE VIEW FROM NORTH



① PERSPECTIVE VIEW FROM SOUTH

	REFERENCE DRAWINGS		REVISIONS		
	NUMBER	DESCRIPTION	DATE	BY	DESCRIPTION
DESIGNED <u>D. PAINE</u>	<u>06/16/11</u>				
	DATE				
DRAWN <u>B. BLOUNT</u>	<u>06/16/11</u>				
	DATE				
CHECKED <u>D. PAINE</u>	<u>06/16/11</u>				
	DATE				
APPROVED <u>D. PAINE</u>	<u>06/16/11</u>				
	DATE				

WASHINGTON METROPOLITAN AREA TRANSIT AUTHORITY



HALF SIZE PRINT		CONTRACT NO.
MTPD DISTRICT II POLICE STATION POLICE TRAINING FACILITY PERSPECTIVE VIEWS		
SCALE:	DRAWING NO. G-08	