

WASHINGTON METROPOLITAN AREA TRANSIT AUTHORITY




WMATA METRO TRAINING CENTER HYATTSVILLE, MARYLAND

GENERAL PLANS

July 23, 2026

WMATA METRO TRAINING CENTER

3636 Pennsy Drive, Hyattsville, MD

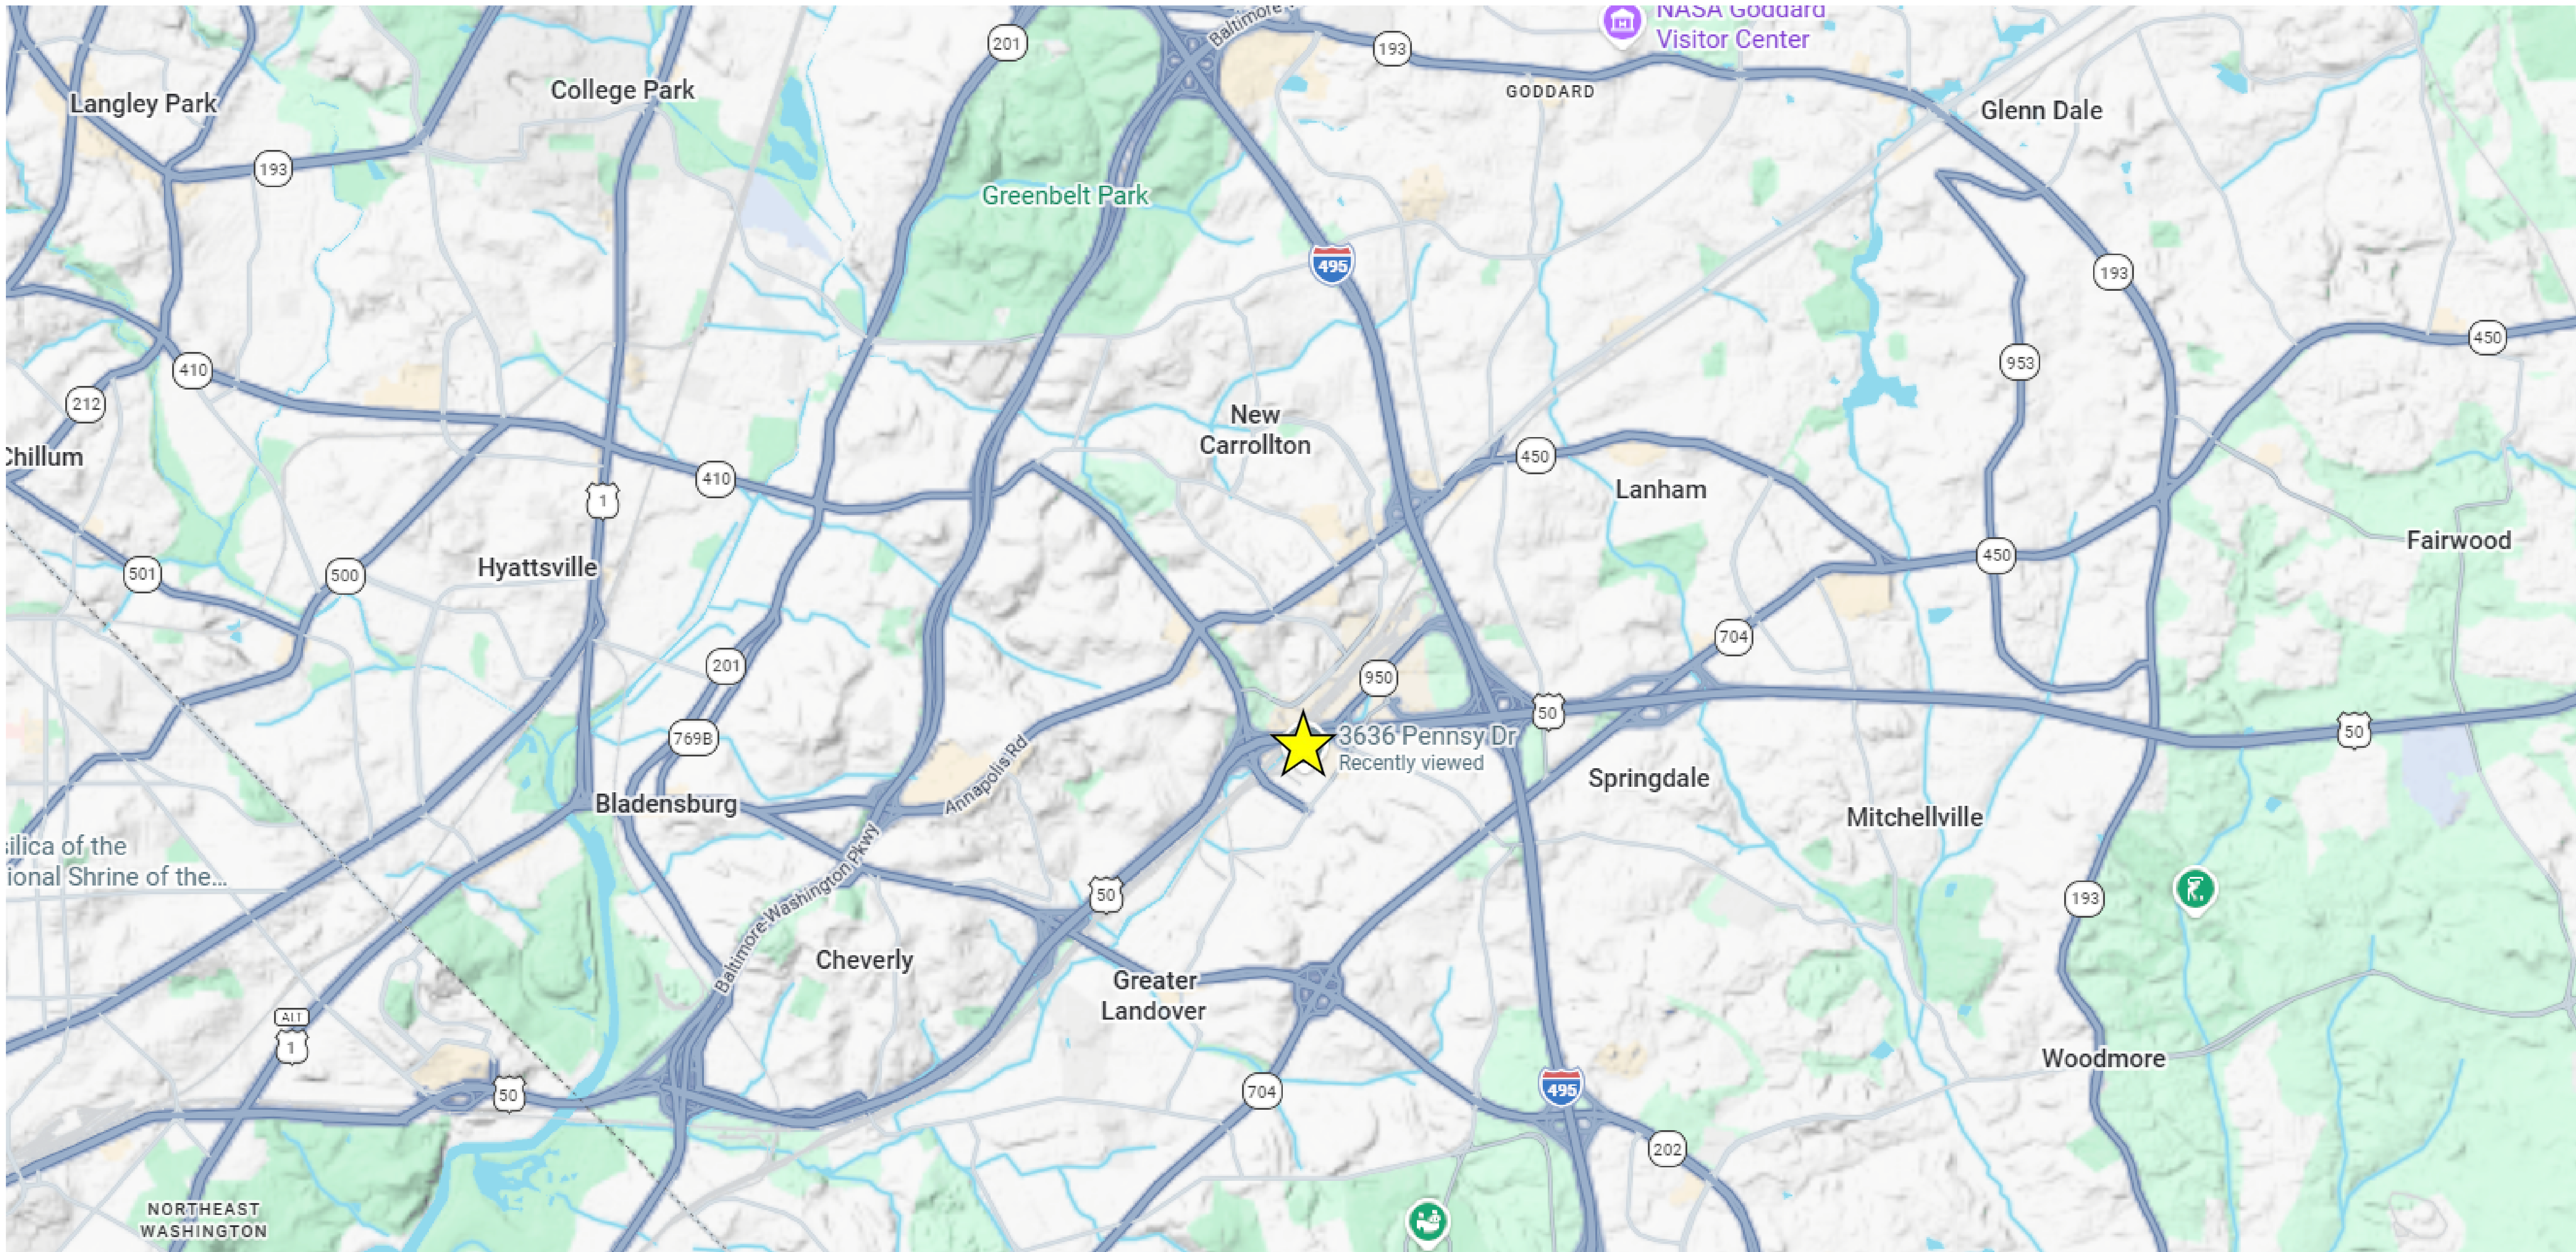

DRAFT WORK-IN-PROGRESS
NOT FOR CONSTRUCTION

"PROFESSIONAL CERTIFICATION: I HEREBY CERTIFY THAT THESE DOCUMENTS WERE PREPARED OR APPROVED BY ME, AND THAT I AM DULY LICENSED ENGINEER UNDER THE LAWS OF THE STATE OF MARYLAND."
LICENSE No. _____ EXPIRATION DATE: _____

CONTRACT NO.
FCIMO255084-PFAC-001

DESIGNED: GM/JM	2026-05-20
	DATE
DRAWN: GM/JM	2026-05-20
	DATE
CHECKED: KM	2026-05-20
	DATE
APPROVED: DG	2026-05-20
	DATE

REFERENCE DRAWINGS	
NUMBER	TITLE

REVISIONS			
DATE	NUM	DESCRIPTION	



WASHINGTON METROPOLITAN AREA TRANSIT AUTHORITY



OFFICE OF PASSENGER FACILITY CONSTRUCTION
INFRASTRUCTURE PROJECT DELIVERY

SUBMITTED BY: KM DATE 2026-05-20 APPROVED BY: DLG DATE 2026-05-20

METRO TRAINING CENTER
LOCATION

SCALE	DRAWING NO.	SHEET NO.
		2 OF 7

DRAWING FILE: Autodesk Docs://24-00450-001- WMATA Metro Training Center/MTC-A-v24_Mirrored - High Bay Concept.rvt
DATE: 7/16/2026 10:07:03 AM

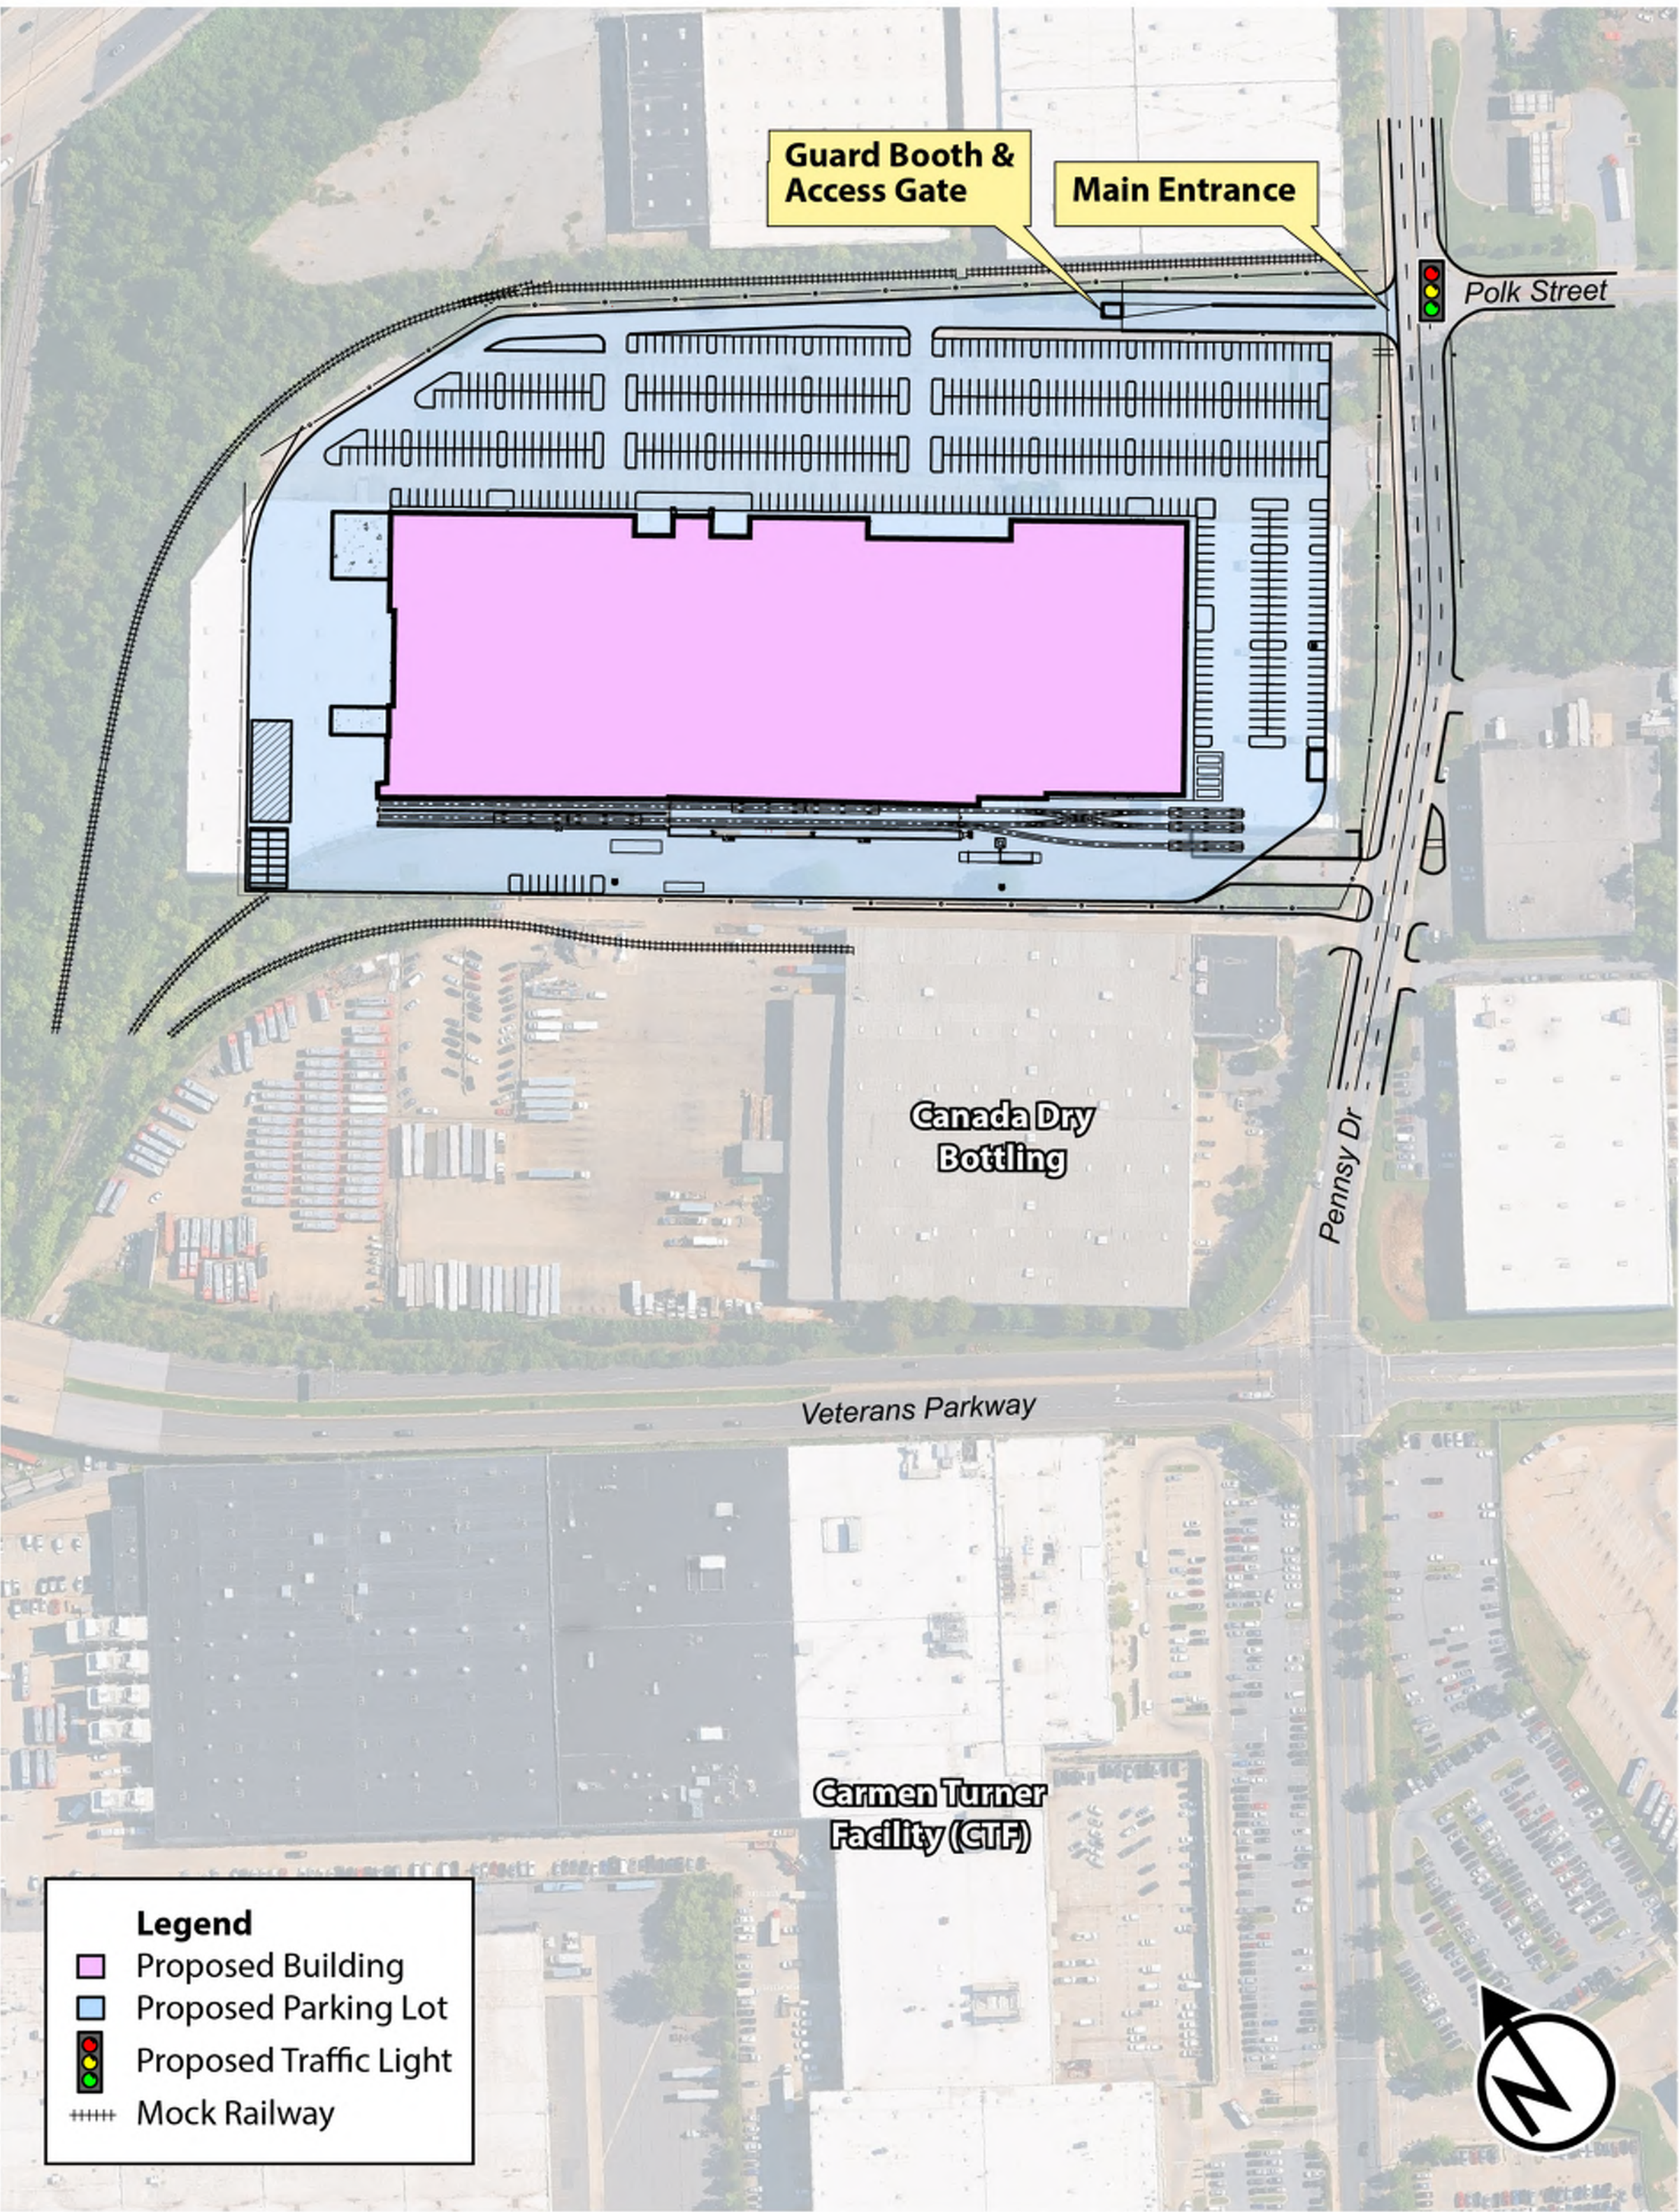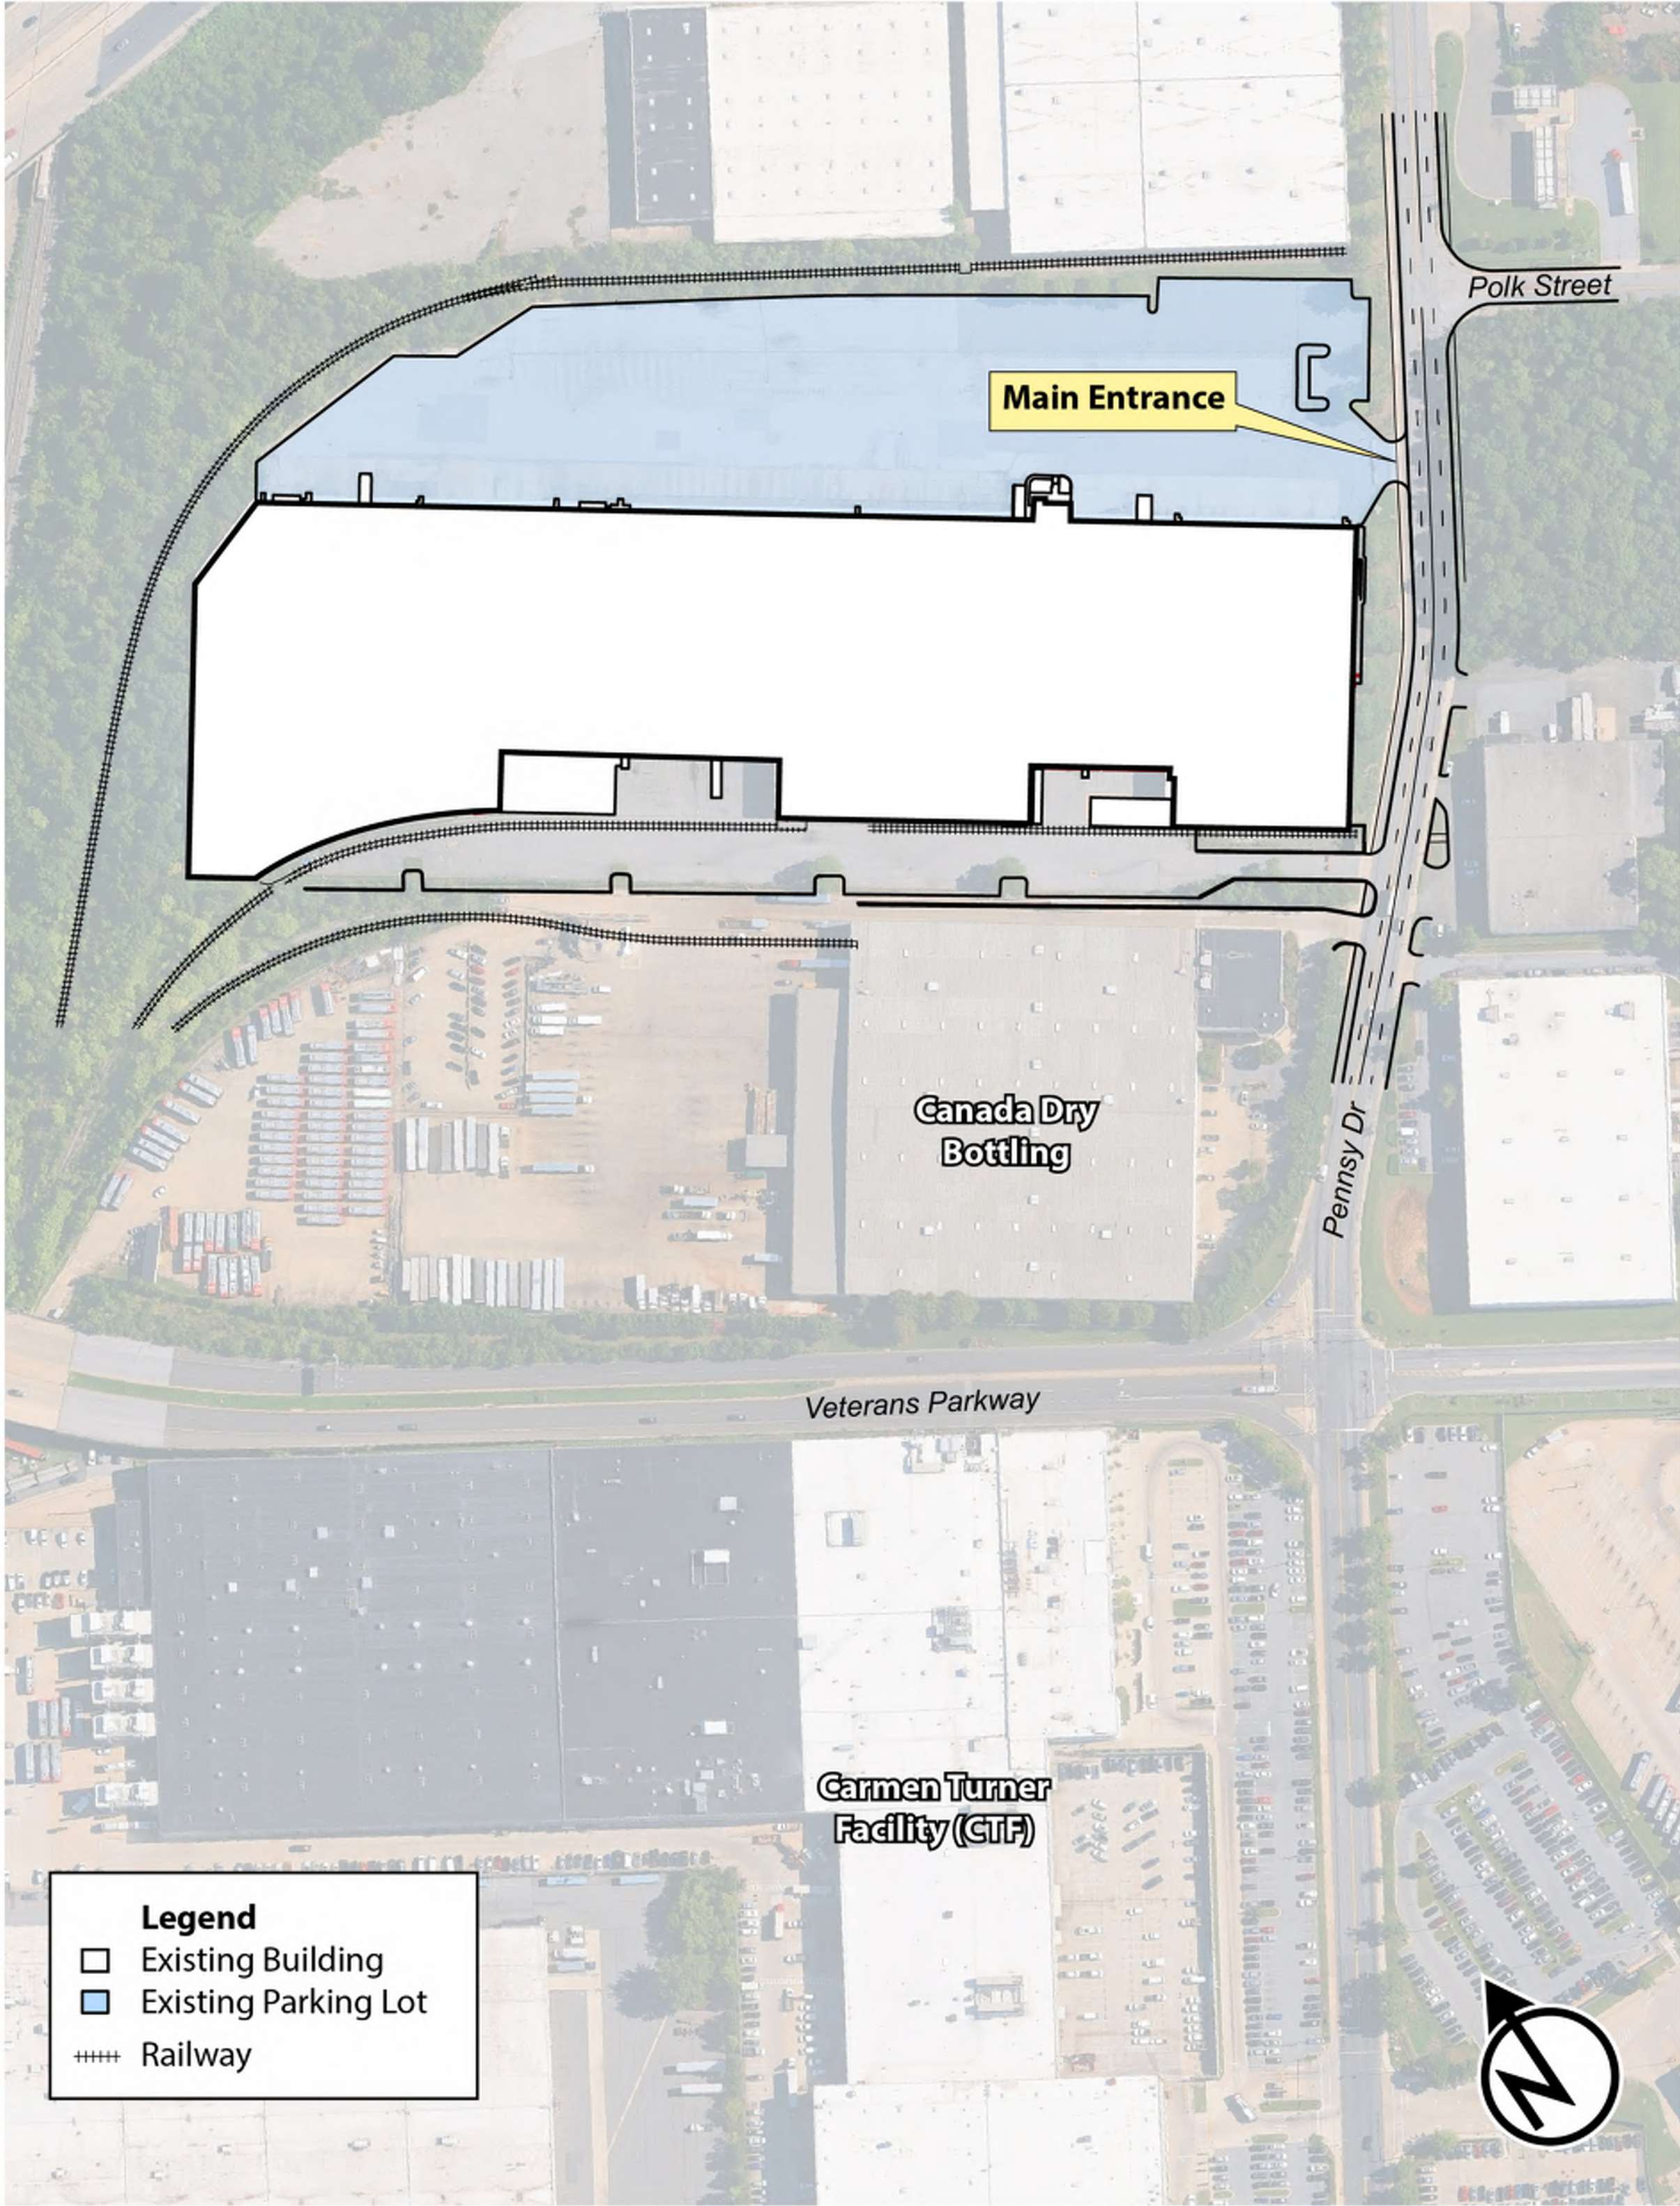

DRAFT WORK-IN-PROGRESS
NOT FOR CONSTRUCTION

"PROFESSIONAL CERTIFICATION: I HEREBY CERTIFY THAT THESE DOCUMENTS WERE PREPARED OR APPROVED BY ME, AND THAT I AM DULY LICENSED ENGINEER UNDER THE LAWS OF THE STATE OF MARYLAND."

LICENSE No. _____ EXPIRATION DATE: _____

CONTRACT NO.
FCIMO255084-PFAC-001

	REFERENCE DRAWINGS		REVISIONS		
	NUMBER	TITLE	DATE	NUM	DESCRIPTION
DESIGNED: GM/JM	2026-05-20				
	DATE				
DRAWN: GM/JM	2026-05-20				
	DATE				
CHECKED: KM	2026-05-20				
	DATE				
APPROVED: DG	2026-05-20				
	DATE				



WASHINGTON METROPOLITAN AREA TRANSIT AUTHORITY


OFFICE OF PASSENGER FACILITY CONSTRUCTION
INFRASTRUCTURE PROJECT DELIVERY

SUBMITTED BY: KM DATE 2026-05-20 APPROVED BY: DLG DATE 2026-05-20


METRO TRAINING CENTER
EXISTING AND PROPOSED CONDITIONS

SCALE	DRAWING NO.	SHEET NO.
		3 OF 7

DRAWING FILE: Autodesk Docs://24-00450-001- WMATA Metro Training Center/MTC-A-v24_Mirrored - High Bay Concept.rvt
DATE: 7/16/2026 10:07:03 AM

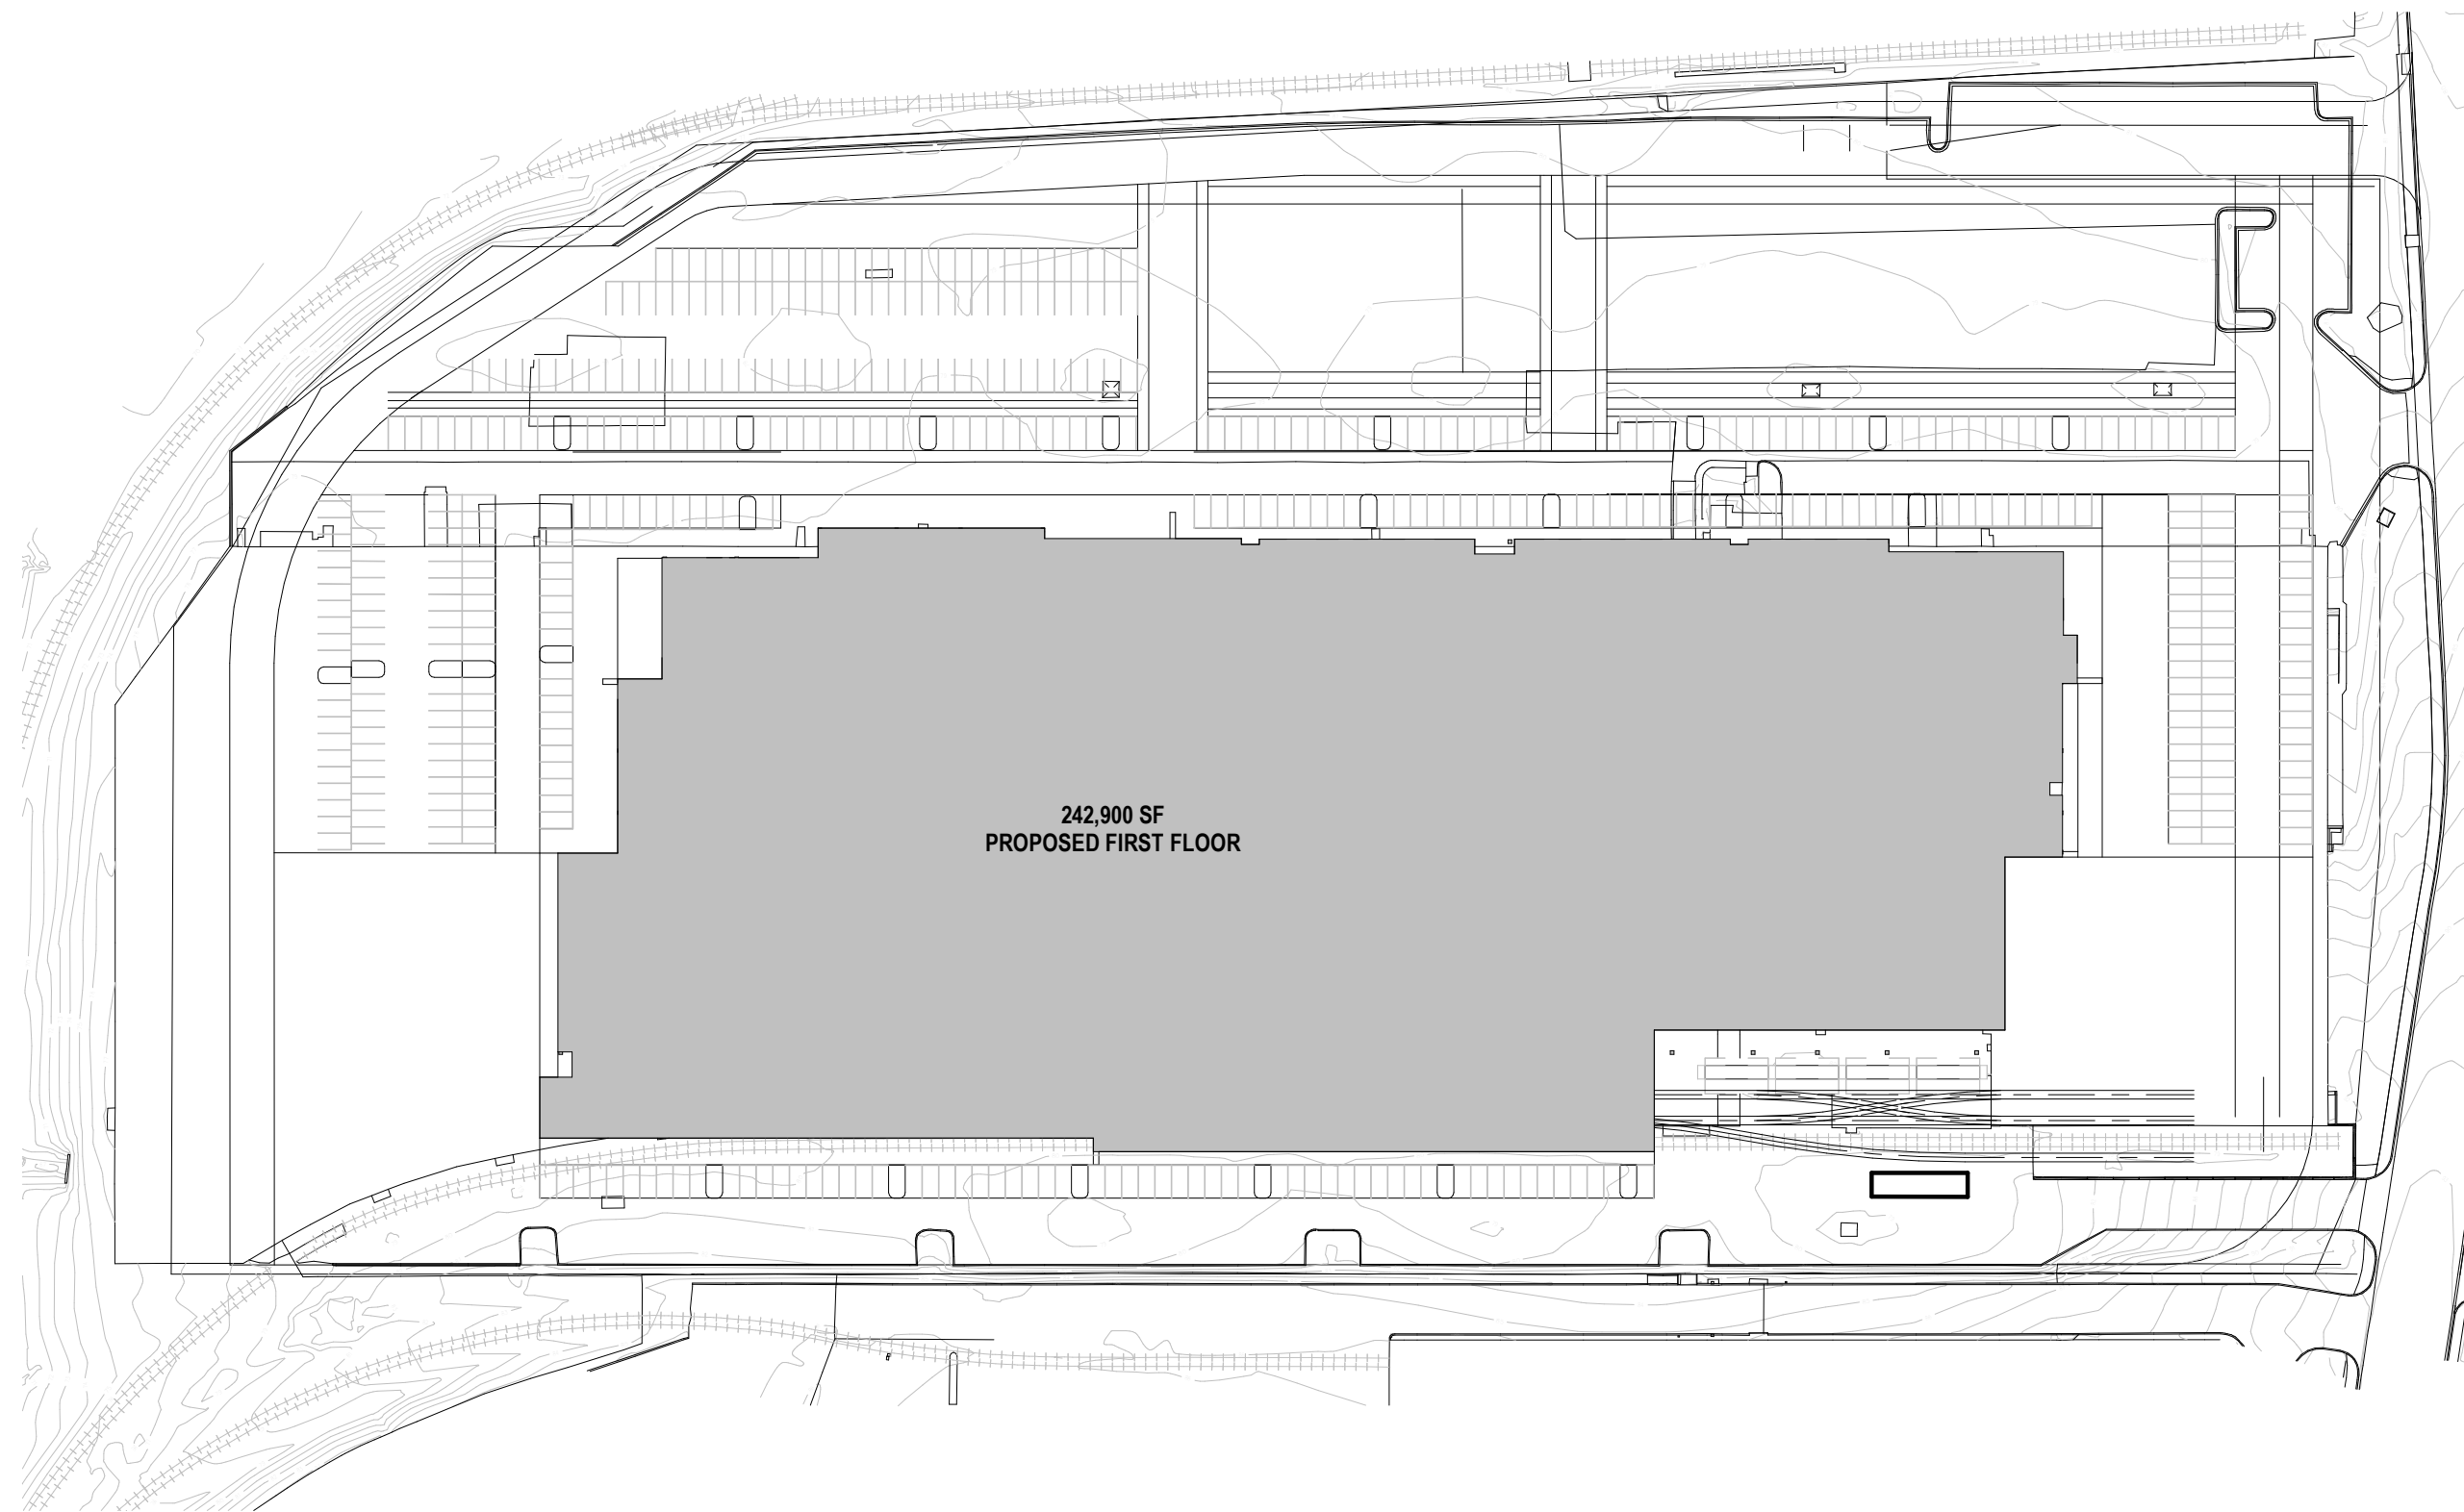

1 PROPOSED PLAN DIAGRAM
1" = 100'-0"

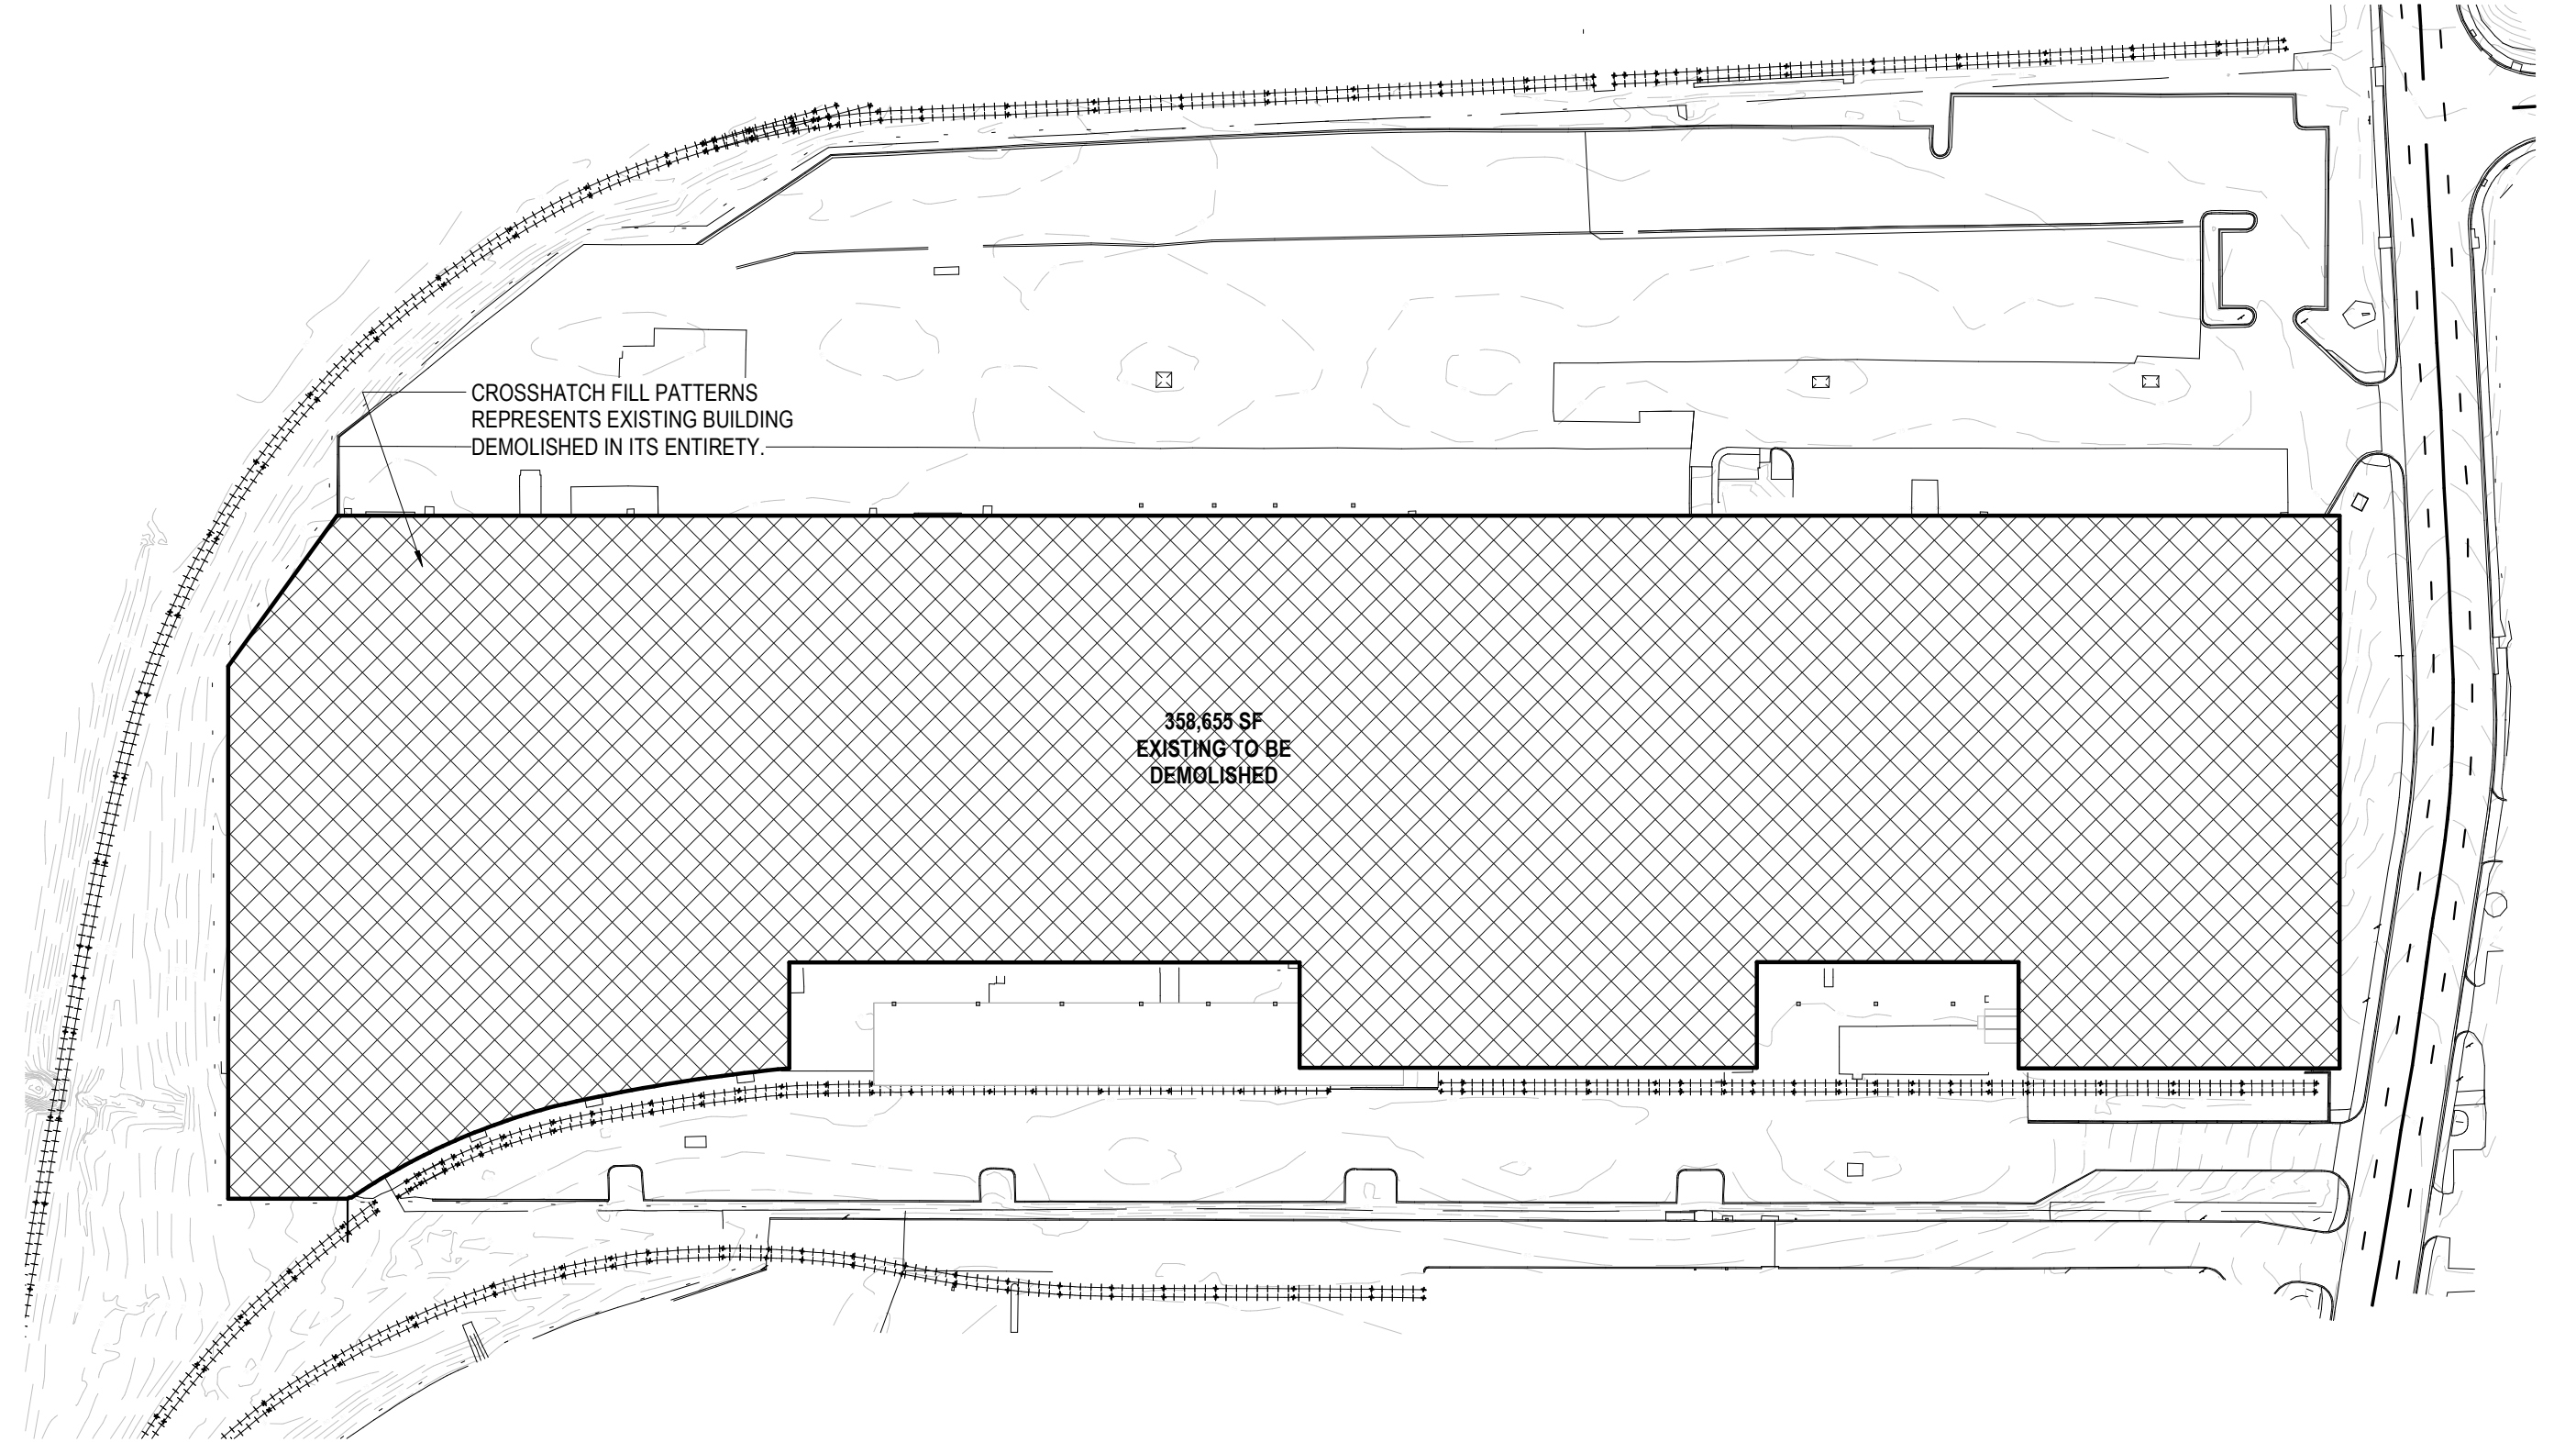

2 DEMOLITION DIAGRAM
1" = 100'-0"

DRAFT WORK-IN-PROGRESS
NOT FOR CONSTRUCTION

"PROFESSIONAL CERTIFICATION: I HEREBY CERTIFY THAT THESE DOCUMENTS WERE PREPARED OR APPROVED BY ME, AND THAT I AM DULY LICENSED ENGINEER UNDER THE LAWS OF THE STATE OF MARYLAND."
LICENSE No. _____ EXPIRATION DATE: _____

CONTRACT NO.
FCIMO255084-PFAC-001

DESIGNED: GM/JM	2026-05-20
	DATE
DRAWN: GM/JM	2026-05-20
	DATE
CHECKED: KM	2026-05-20
	DATE
APPROVED: DG	2026-05-20
	DATE

REFERENCE DRAWINGS	
NUMBER	TITLE

REVISIONS				
DATE	NUM	DESCRIPTION		



WASHINGTON METROPOLITAN AREA TRANSIT AUTHORITY

OFFICE OF PASSENGER FACILITY CONSTRUCTION
INFRASTRUCTURE PROJECT DELIVERY

SUBMITTED BY: KM DATE 2026-05-20 APPROVED BY: DLG DATE 2026-05-20


METRO TRAINING CENTER
REVISED 10% CONCEPT
PROPOSED PLAN AND DEMOLITION DIAGRAMS

SCALE
1" = 100'-0"

DRAWING NO.
SK-001

SHEET NO.
4 OF 7

- AUDITORIUM
- BMNT / CMNT
- STRN
- LOBBY / CIRCULATION / COLLAB
- MTPD
- CEP
- RAIL
- ROGT
- SERVICE
- TTDV
- TTRN

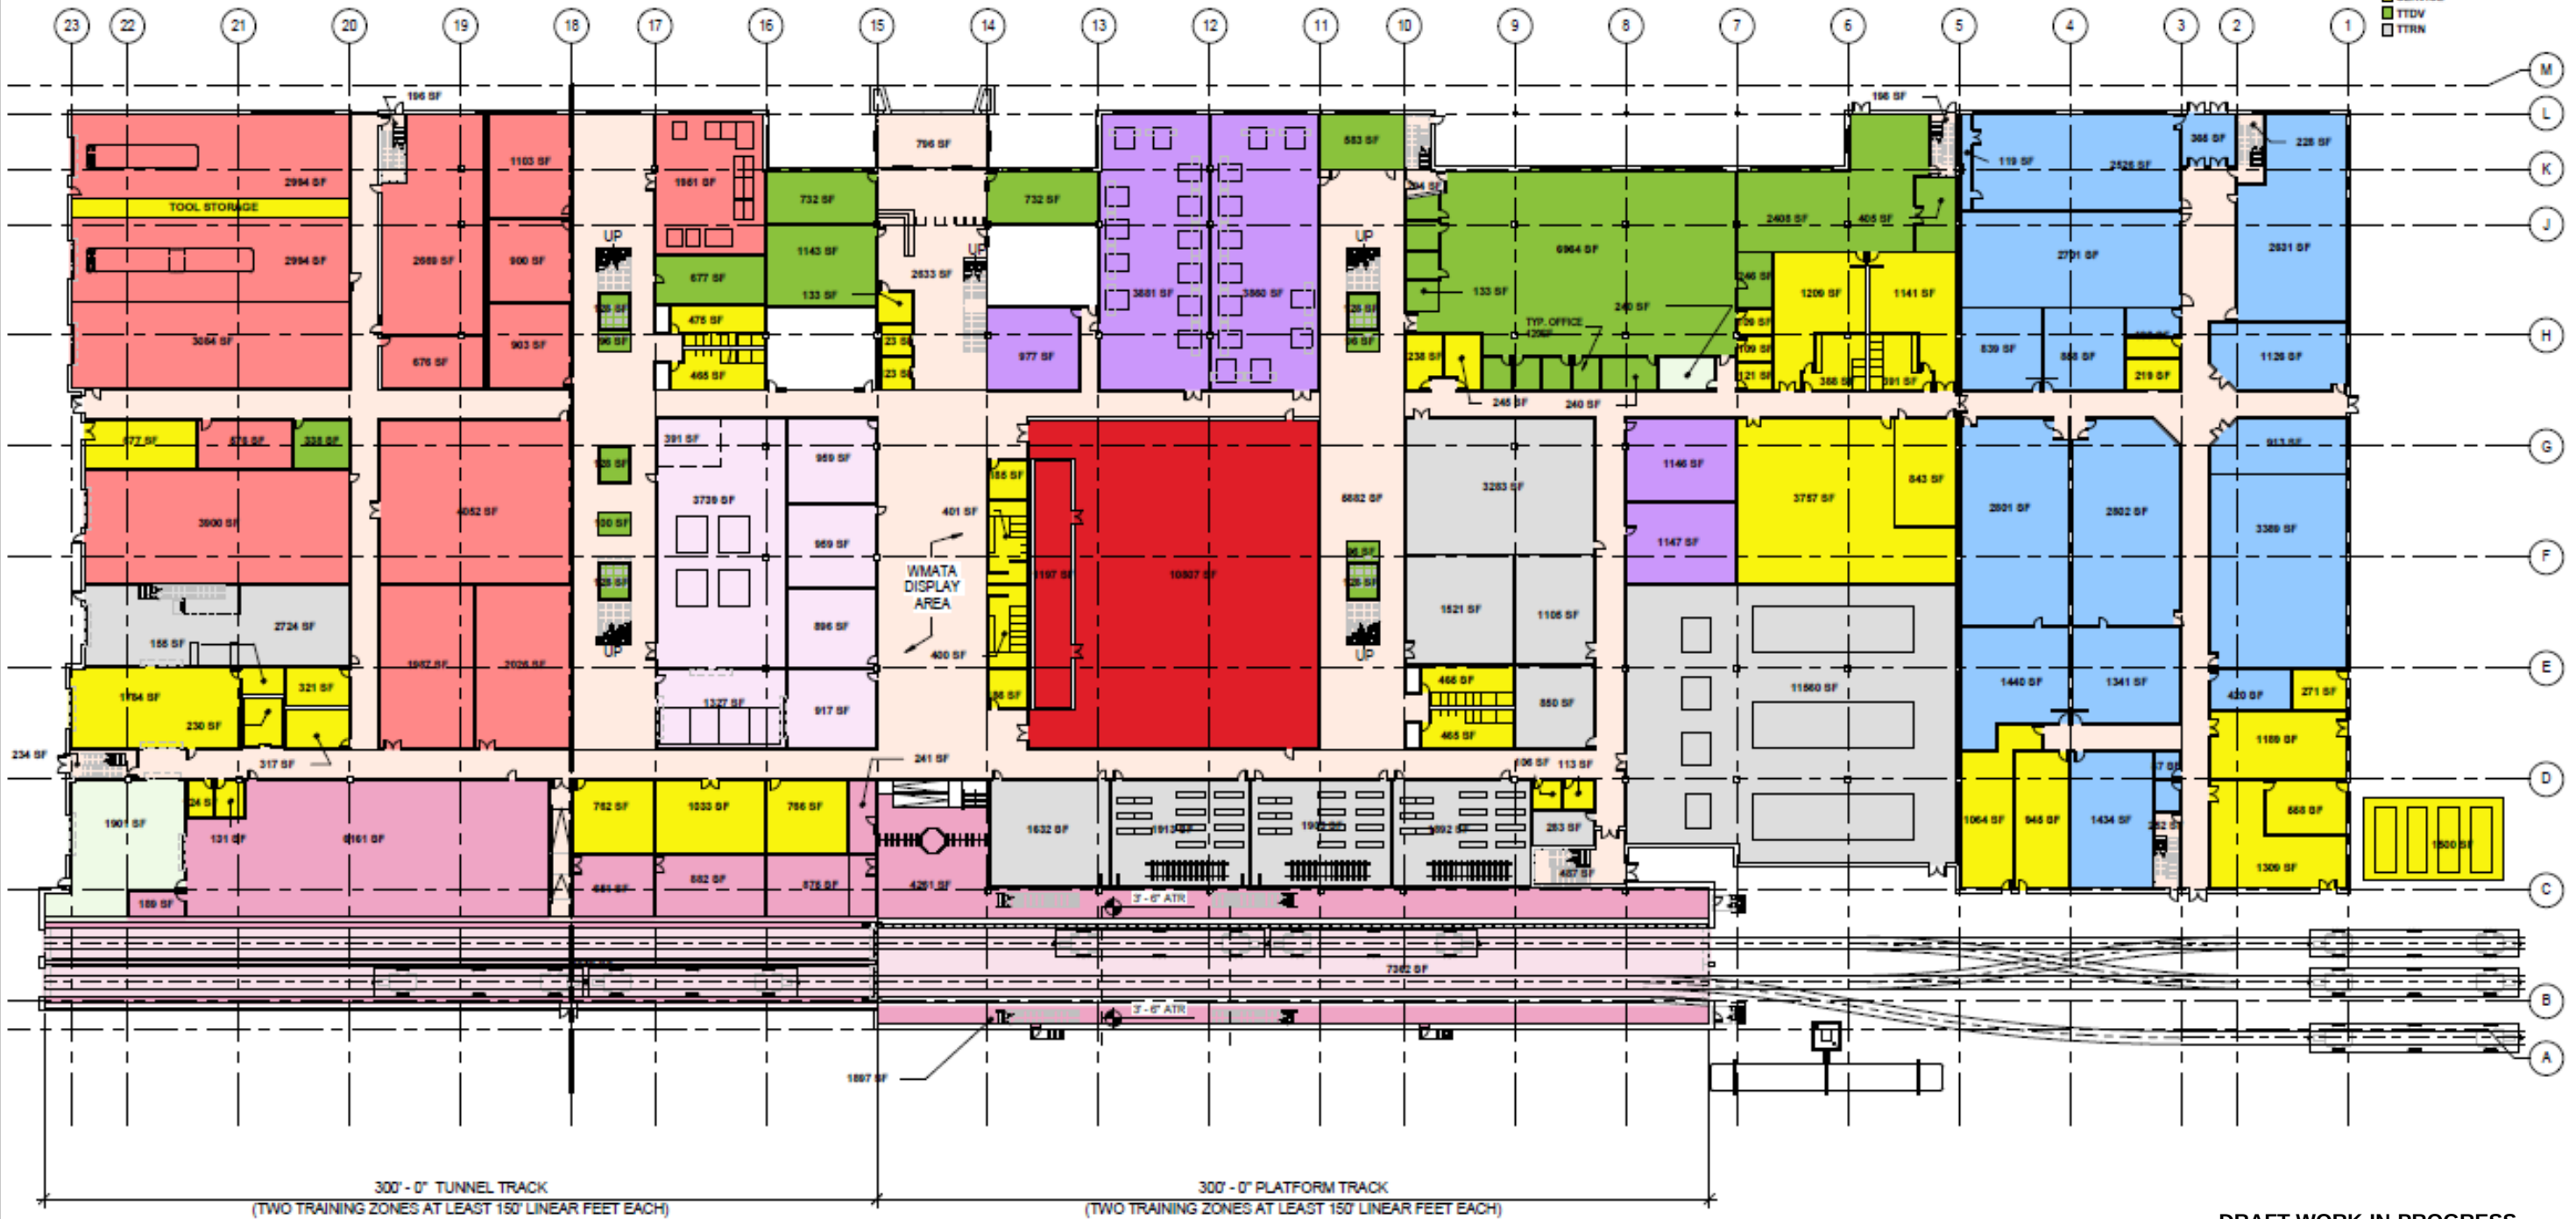

DRAFT WORK-IN-PROGRESS
NOT FOR CONSTRUCTION

1 SK101 REVISED 10% CONCEPT FIRST FLOOR PLAN - OVERALL
NTS

"PROFESSIONAL CERTIFICATION: I HEREBY CERTIFY THAT THESE DOCUMENTS WERE PREPARED OR APPROVED BY ME, AND THAT I AM DULY LICENSED ENGINEER UNDER THE LAWS OF THE STATE OF MARYLAND."
LICENSE No. _____ EXPIRATION DATE: _____

CONTRACT NO.
FCMO255084-PFAC-001

DESIGNED: <u>Designer</u>	DATE	REFERENCE DRAWINGS		REVISIONS	
		NUMBER	TITLE	DATE	NUM DESCRIPTION
DRAWN: <u>Author</u>	DATE				
CHECKED: <u>Checker</u>	DATE				
APPROVED: <u>Approver</u>	DATE				



WASHINGTON METROPOLITAN AREA TRANSIT AUTHORITY

OFFICE OF PASSENGER FACILITY CONSTRUCTION
INFRASTRUCTURE PROJECT DELIVERY

 
SUBMITTED BY: KM DATE: 2025-05-20 APPROVED BY: DLG DATE: 2025-05-20

METRO TRAINING CENTER
REVISED 10% CONCEPT
REVISED 10% CONCEPT FIRST FLOOR PLAN - OVERALL

SCALE
1" = 30'-0"

DRAWING NO.
SK101

SHEET NO.
5 OF 7



CONTRACT NO.
FCIM0256084-PFAC-001

SUBMITTED BY: KM DATE: 2025-05-20 APPROVED BY: DLG DATE: 2025-05-20

SHEET NO.
6 OF 7

