


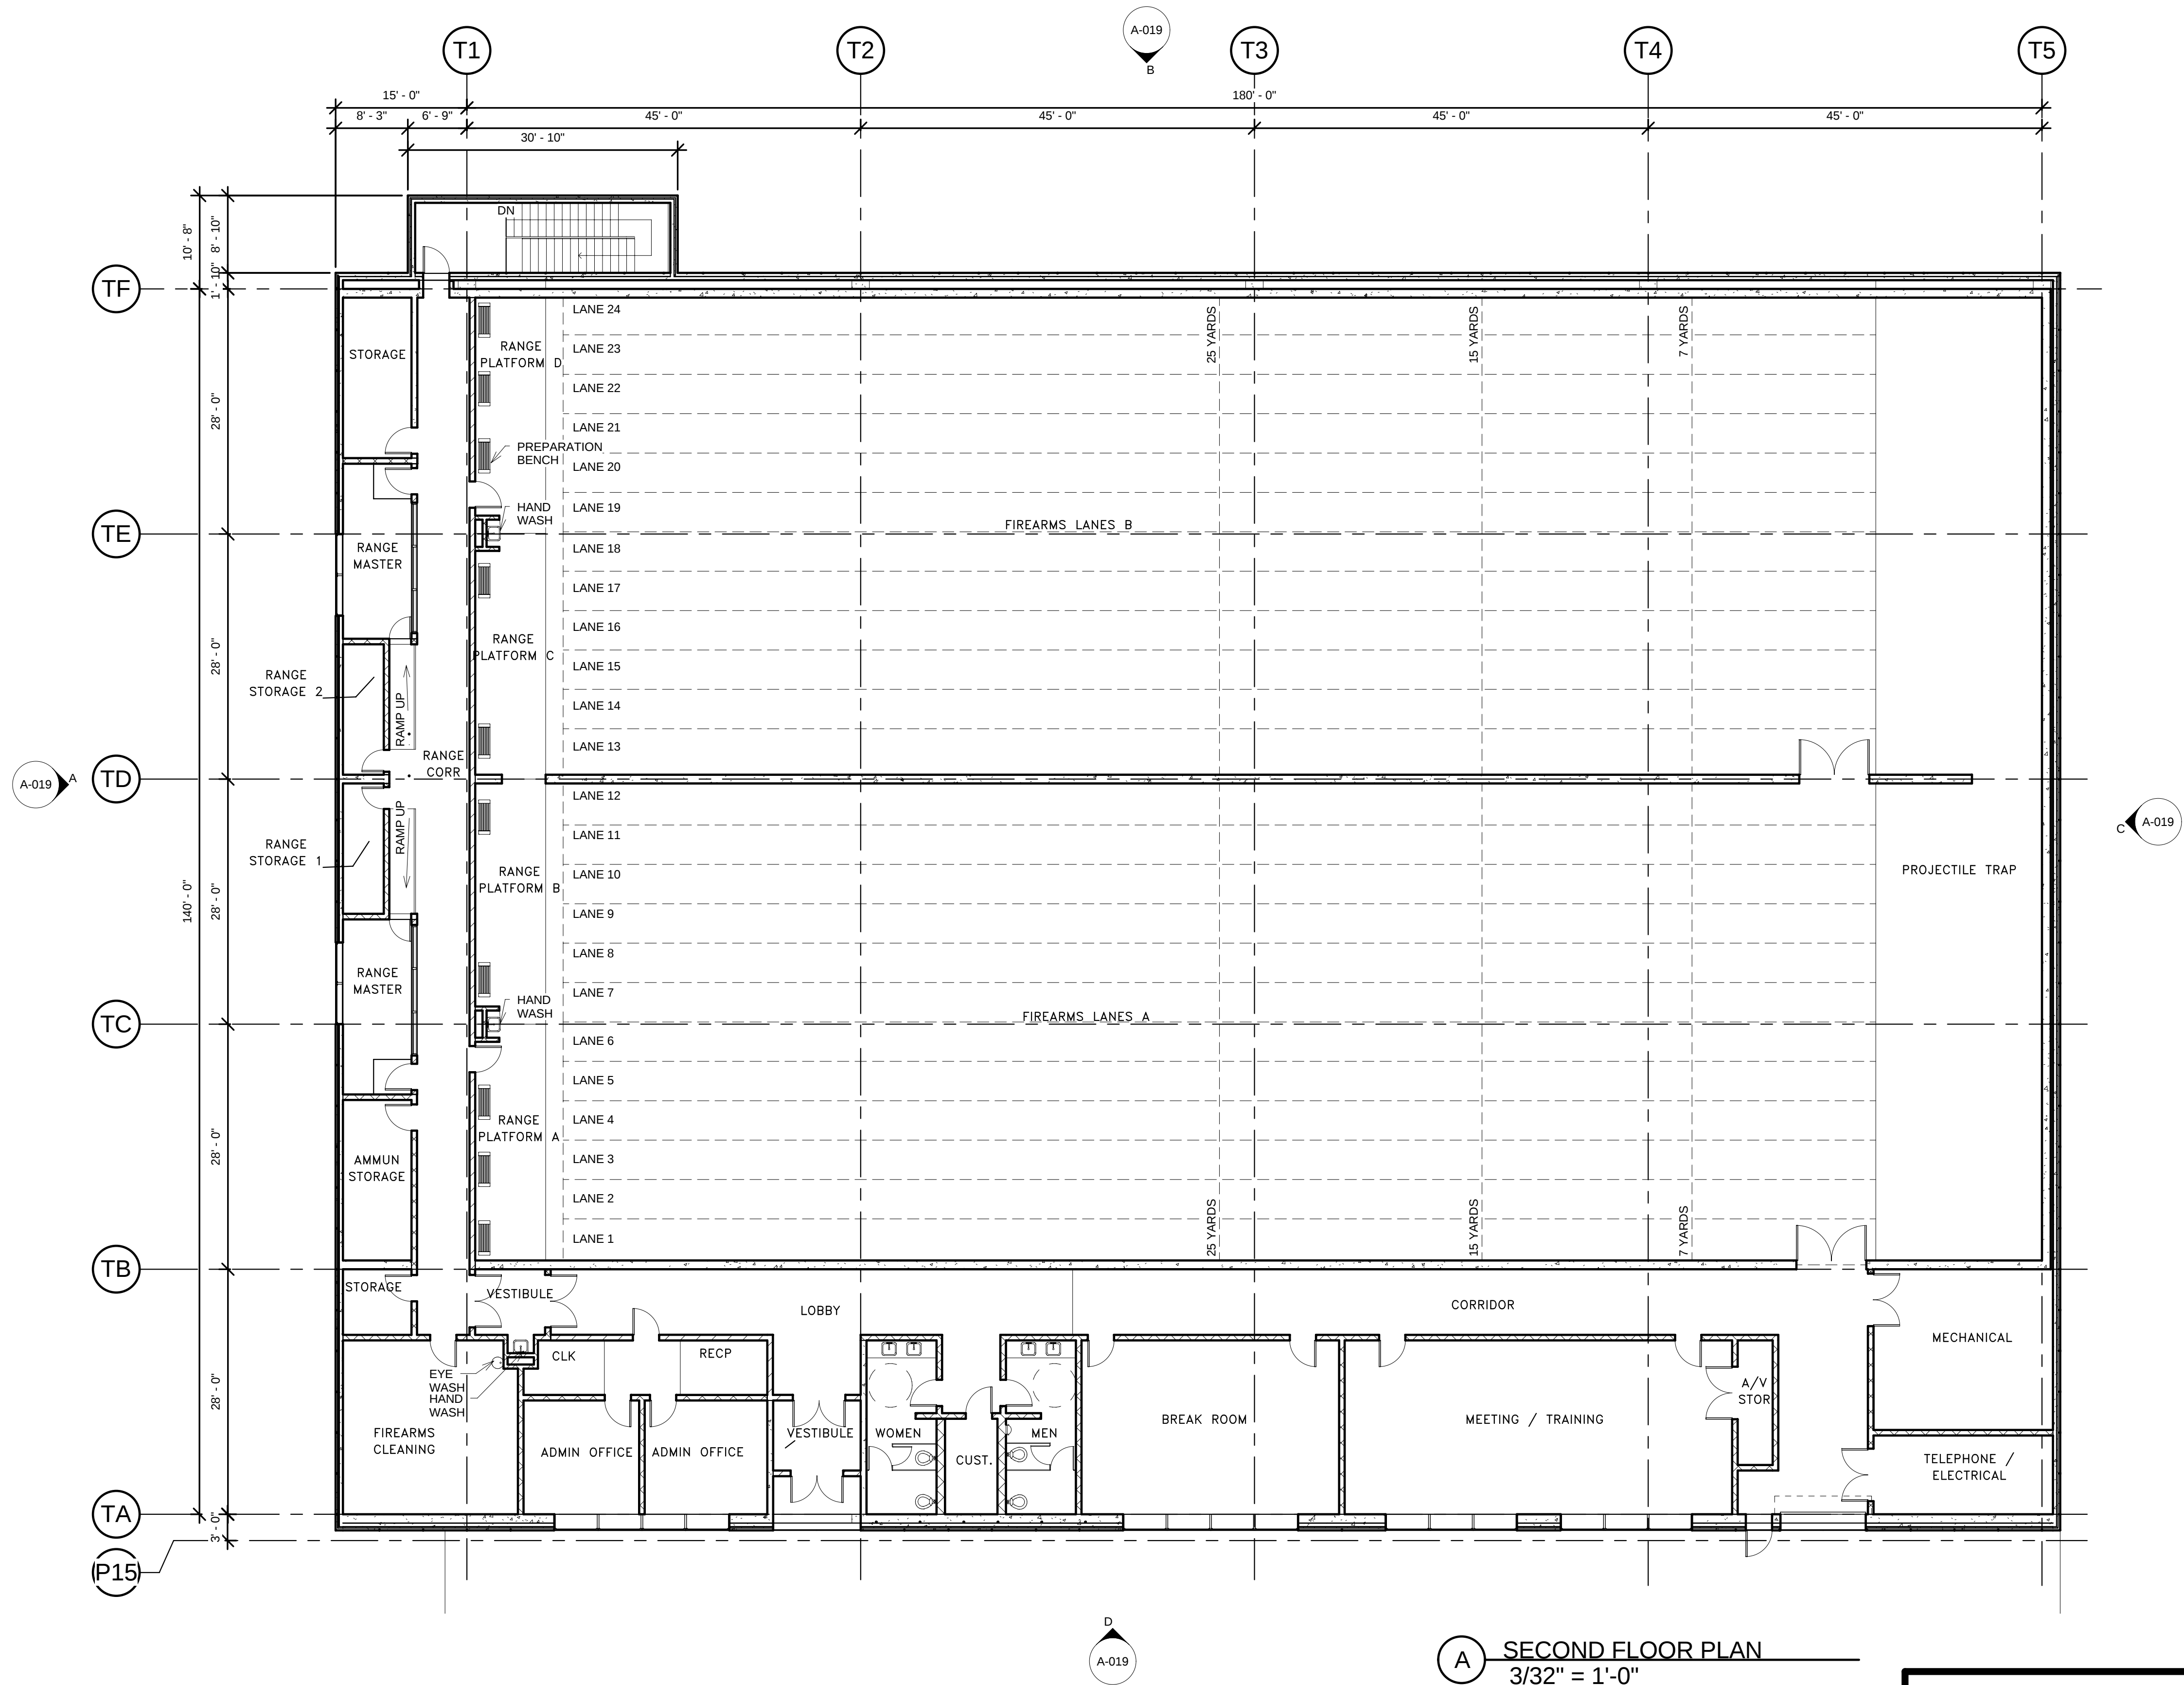

A SECOND FLOOR PLAN
3/32" = 1'-0"

DESIGNED	KP	11/01/07
DRAWN	MCJr	11/01/07
CHECKED	DVS	11/01/07
APPROVED	DC	11/01/07

REFERENCE DRAWINGS	
NUMBER	DESCRIPTION

REVISIONS		
DATE	BY	DESCRIPTION

WASHINGTON METROPOLITAN AREA TRANSIT AUTHORITY



a joint venture of:
•Parsons Transportation Group Inc.
•Parsons Brinckerhoff Quade & Douglas, Inc.
•Delon Hampton & Associates, Chartered

PROJECT MANAGER



FULL SIZE PRINT	---	CONTRACT NO: ---
SOUTHEASTERN BUS GARAGE REPLACEMENT DC VILLAGE WASHINGTON DC PHASE 3 TRANSIT POLICE TRAINING FACILITY SECOND FLOOR PLAN		
SCALE: 3/32" = 1'-0"	DRAWING NO. A-017	25 OF 26