


ABBREVIATIONS

@	AT	FL FLR	FLOOR	R RAD	RADIUS
ACI	AMERICAN CONCRETE INSTITUTE	FLOUR	FLOURESCENT	R	RISER /S
ACT	ACOUSTICAL CEILING TILES	FSP	FIRE STAND PIPE	RB	ROOF BEAM
AD	AREA DRAIN	FT (')	FEET	RD	ROOF DRAIN
ADD	ADDITIONAL	FTG	FOOTING	RECPT	RECEPTACLE
ADJ	ADJACENT	FUT	FUTURE	REINF	REINFORCING
AFF	ABOVE FINISHED FLOOR	GA	GAGE	REQ'D	REQUIRED
AGGR	AGGREGATE	GALV	GALVANIZED	RET	RETAINING
AIR COND	AIR CONDITION	GB	GRADE BEAM	RF	ROOF
AISC	AMERICAN INSTITUTE OF STEEL CONSTRUCTION	GC	GENERAL CONTRACTOR	RH	RIGHT HAND
		GEN	GENERAL	RM	ROOM
		GL	GLASS	RO	ROUGH OPENING
AL ALUM	ALUMINUM	GPM	GALLONS PER MINUTE	ROW	RIGHT OF WAY
ALT	ALTERNATE	GRD	GRADE		
ANOD	ANODIZED	GYP	GYPSUM	SCH	SCHEDULE
APPD	APPROVED	GYP BD	GYPSUM BOARD	SECT	SECTION
APPROX	APPROXIMATE	HDCP	HANDICAPPED	SF	SQUARE FEET
ARCH	ARCHITECTURAL	HDR	HEADER	SHT	SHEET
ASTM	AMERICAN SOCIETY FOR TESTING AND MATERIALS	HDW	HARDWARE	SIM	SIMILAR
		HK	HOOK	SK	SKETCH
AVE	AVENUE	HM	HOLLOW METAL	SL	SLAB
		HORIZ	HORIZONTAL	SN	SINGLE
		HP	HIGH POINT	SPEC	SPECIFICATION
		HT HGT	HEIGHT	SQ	SQUARE
		HTR	HEATER	SS	STAINLESS STEEL
		HVAC	HEATING VENTILATING & AIR CONDITONING	ST	STREET
			HOT WATER	STD	STANDARD
		HW	HIGHWAY	STL	STEEL
		HWY		STOR	STORAGE
		ID	INSIDE DIAMETER	STRUCT	STRUCTURAL
		IN (")	INCH	SW	SWITCH
		INFO	INFORMATION		
		INSUL	INSULATION	T	TREAD/S
		INT	INTERIOR	T&B	TOP & BOTTOM
		INV	INVERT	T/BM	TOP OF BEAM
		JST	JOIST	T/C	TOP OF CURB
		JT	JOINT	TEL	TELEPHONE
		K	KIPS		
		K&R	KISS AND RIDE AREA	TEMP	TEMPERATURE
		KO	KNOCK-OUT	TH THK	THICK
		KSP	KIPS PER SQUARE FOOT	TO T/	TOP OF
		KSI	KIPS PER SQUARE INCH	TOIL	TOILET
		KW	KILOWATT	TOS T/S	TOP OF SLAB
		LAM	LAMINATED	TOS T/STL	TOP OF STEEL
		LAV	LAVATORY	TOW T/W	TOP OF WALL
		LH	LEFT HAND	T/PC	TOP OF PILE CAP
		LL	LIVE LOAD	TYP	TYPICAL
		LTP	LIGHT POLE		
		LP	LOW POINT	UL	UNDERWRITER'S LABORATORIES
		LT	LIGHT	UNO	UNLESS NOTED OTHERWISE
		LTG	LIGHTING		
		MAX	MAXIMUM	V	VOLTS
		MECH	MECHANICAL	VENT	VENTILATE
		MED	MEDIUM	VERT	VERTICAL
		MEZZ	MEZZANINE	VP	VENT PIPE
		MFG	MANUFACTURER		
		MH	MANHOLE	W/	WITH
		MIN	MINIMUM	WC	WATER CLOSET
		MISC	MISCELLANEOUS	W/O	WITHOUT
		MTD	MOUNTED	WP	WEATHER-PROOF
		MTG	MOUNTING	WWF	WELDED WIRE FABRIC
				WWM	WELDED WIRE MESH
		NEC	NATIONAL ELECTRICAL CODE		
		NIC	NOT IN CONTRACT		
		NO (#)	NUMBER		
		NOM	NOMINAL		
		NTS	NOT TO SCALE		
		OC	ON CENTER		
		OD	OUTSIDE DIAMETER		
		OPNG	OPENING		
		OPP	OPPOSITE		
		OPP HAND	OPPOSITE HAND		
EA	EACH	PLC	PILE CAP		
EF	EACH FACE	PC	PRECAST		
EL	ELEVATION	PED	PEDESTRIAN		
ELEC	ELECTRIC	PH	PANIC HARDWARE		
ELEV	ELEVATOR	PL	PLATE		
EMERG	EMERGENCY	P	PROPERTY LINE		
EQ	EQUAL	PLWD	PLYWOOD		
EQUIP	EQUIPMENT	PNL	PANEL		
EW	EACH WAY	PPT	PARAPET		
EXH	EXHAUST	PSI	POUNDS PER SQUARE INCH		
EXIST	EXISTING	PT	POST TENSIONED		
EXP	EXPANSION	PTN	PARTITION		
EXP JT	EXPANSION JOINT				
EXT	EXTERIOR				
FD	FLOOR DRAIN				
FDN	FOUNDATION				
FE	FIRE EXTINGUISHER				
FEC	FIRE EXTINGUISHER CABINET				
FHC	FIRE HOSE CABINET				
FIN	FINISHED				

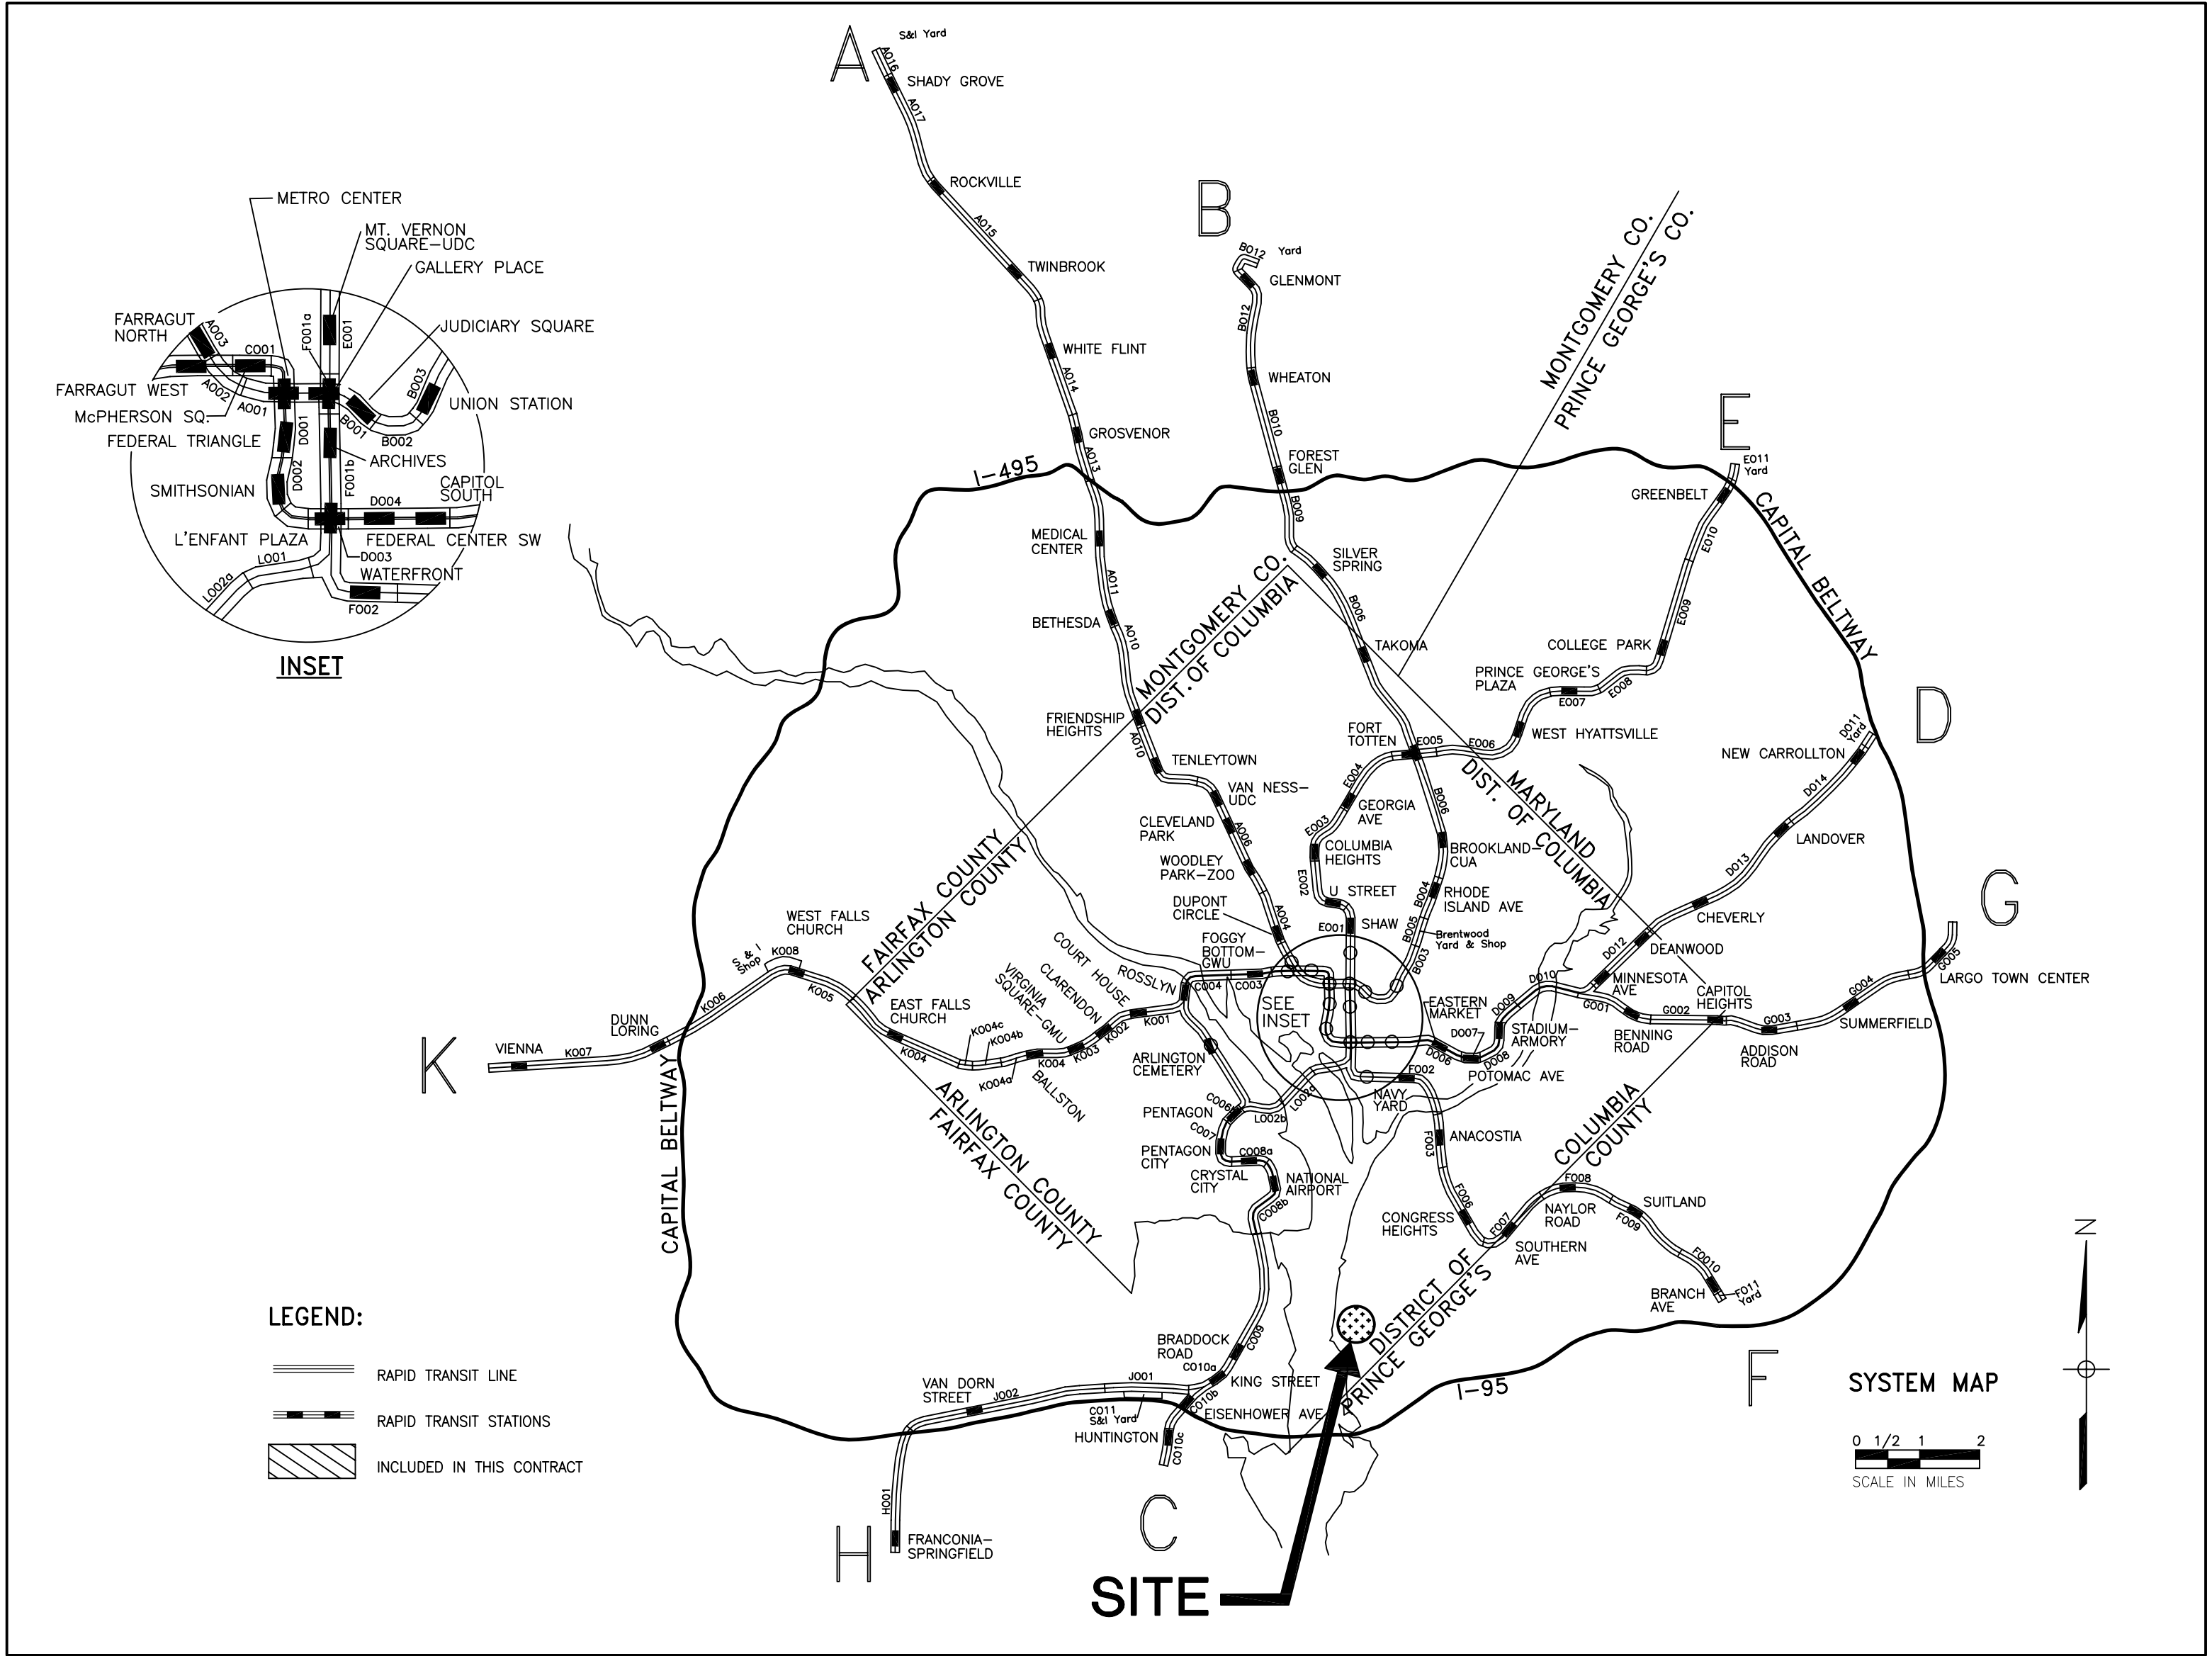

SYSTEM MAP

DRAWING LIST					
SHEET #	DRAWING #	TITLE	SHEET #	DRAWING #	TITLE
1 OF 24	G-001	COVER	16 OF 24	A-008	PHASE 1 CLEANING FACILITY FLOOR PLAN
2 OF 24	G-002	ABBREVIATIONS/SYSTEM MAP/DRAWING LIST	17 OF 24	A-009	PHASE 1 CLEANING FACILITY ELEVATIONS
3 OF 24	G-003	RENDERING	18 OF 24	A-010	PHASE 2 MAINTENANCE GARAGE FIRST FLOOR PLAN
			19 OF 24	A-011	PHASE 2 MAINTENANCE GARAGE ELEVATIONS
4 OF 24	ST-001	PROPERTY IDENTIFICATION PLAN	20 OF 24	A-012	PHASE 3 EMPLOYEE PARKING STRUCTURE FLOOR PLAN
5 OF 24	ST-002	PHASE 1 TEMPORARY SITE PLAN	21 OF 24	A-013	PHASE 3 EMPLOYEE PARKING STRUCTURE ELEVATIONS
6 OF 24	ST-003	PHASE 1 PERMANENT SITE PLAN	22 OF 24	A-014	PHASE 3 MAINTENANCE GARAGE FIRST FLOOR PLAN
7 OF 24	ST-004	PHASE 2 SITE PLAN	23 OF 24	A-015	PHASE 3 MAINTENANCE GARAGE SECOND FLOOR PLAN
8 OF 24	ST-005	PHASE 3 SITE PLAN	24 OF 24	A-016	PHASE 3 MAINTENANCE GARAGE ELEVATIONS
9 OF 24	A-001	PHASE 1 TEMPORARY MAINTENANCE GARAGE FLOOR PLAN			
10 OF 24	A-002	PHASE 1 TEMPORARY MAINTENANCE GARAGE ELEVATIONS			
11 OF 24	A-003	PHASE 1 TEMPORARY OPERATIONS BUILDING FLOOR PLAN			
12 OF 24	A-004	PHASE 1 PERMANENT MAINTENANCE GARAGE FIRST & SECOND FLOOR PLANS			
13 OF 24	A-005	PHASE 1 PERMANENT MAINTENANCE GARAGE ELEVATIONS			
14 OF 24	A-006	PHASE 1 FUELING FACILITY FLOOR PLAN			
15 OF 24	A-007	PHASE 1 FUELING FACILITY ELEVATIONS			

DESIGNED		REFERENCE DRAWINGS		REVISIONS		
JC	05/24/07	NUMBER	DESCRIPTION	DATE	BY	DESCRIPTION

WASHINGTON METROPOLITAN AREA TRANSIT AUTHORITY

a joint venture of:

•Parsons Transportation Group Inc.

•Parsons Brinckerhoff Quade & Douglas, Inc.

•Delon Hampton & Associated, Chartered

PROJECT MANAGER

M

metro

FULL SIZE PRINT

CONTRACT NO. ---

SOUTHEASTERN BUS GARAGE REPLACEMENT
DC VILLAGE
WASHINGTON DC
ABBREVIATIONS, SYSTEM MAP AND DRAWING LIST

SCALE: NOT TO SCALE

DRAWING NO. G-002

2 OF 24